


INTERIOR FINISH LEGEND


FINISH NO.	MATERIAL	MANUFACTURER	STYLE NAME / NO.	COLOR	SIZE	RESPONSIBILITY	DESCRIPTION / REMARKS
ACOUSTIC CEILING TILE							
ACT-001	CEILING TILE						
CARPET							
CPT-001	CARPET	MOHAWK	COLOR BALANCE	OPTIC			
CPT-002	CARPET	MOHAWK	DISRUPTED PATH	PURPLE DAWN			
CPT-003	CARPET	MOHAWK	COLOR BALANCE	MYSTIC			
CPT-004	CARPET	FLOR	REORIENTED	LAVENDAR			
PAINT							
PNT-001	PAINT	SHERWIN WILLIAMS	CEILING BRIGHT WHITE		N/A		EGGSHELL
PNT-002	PAINT	SHERWIN WILLIAMS	PURE WHITE		N/A		EGGSHELL
PNT-003	PAINT	SHERWIN WILLIAMS	KRYPTON		N/A		EGGSHELL - ACCENT GRAY
PNT-004	PAINT	SHERWIN WILLIAMS	TURKISH TILE		N/A		EGGSHELL - ACCENT DARK BLUE
PNT-005	PAINT	SHERWIN WILLIAMS	LUXE BLUE		N/A		EGGSHELL - ACCENT DARK PURPLE
PNT-006	PAINT	SHERWIN WILLIAMS	GBRALTAR		N/A		EGGSHELL - ACCENT DARK GREY
PNT-007	PAINT	SHERWIN WILLIAMS	FADED FLAXFLOWER		N/A		EGGSHELL - ACCENT LIGHT BLUE
PLASTIC LAMINATE							
PLAM-001	PLASTIC LAMINATE	WILSONART	LINEN D427-60				WHITE
PLAM-002	PLASTIC LAMINATE	WILSONART	NEW AGE OAK 7938-88				WOOD LOOK
PLAM-003	PLASTIC LAMINATE	WILSONART	BLACK				BLACK
PLAM-004	PLASTIC LAMINATE	WILSONART	TO MATCH PNT-006				TO MATCH PNT-006
SOLID SURFACE MATERIAL							
SSM-001	SOLID SURFACE MATERIAL	CORIAN	ENDURA	DEEP METAL	CUSTOM		
STONE							
ST-001	STONE	DALTILE	ONE QUARTZ	NO90 WHITE ICE	CUSTOM		

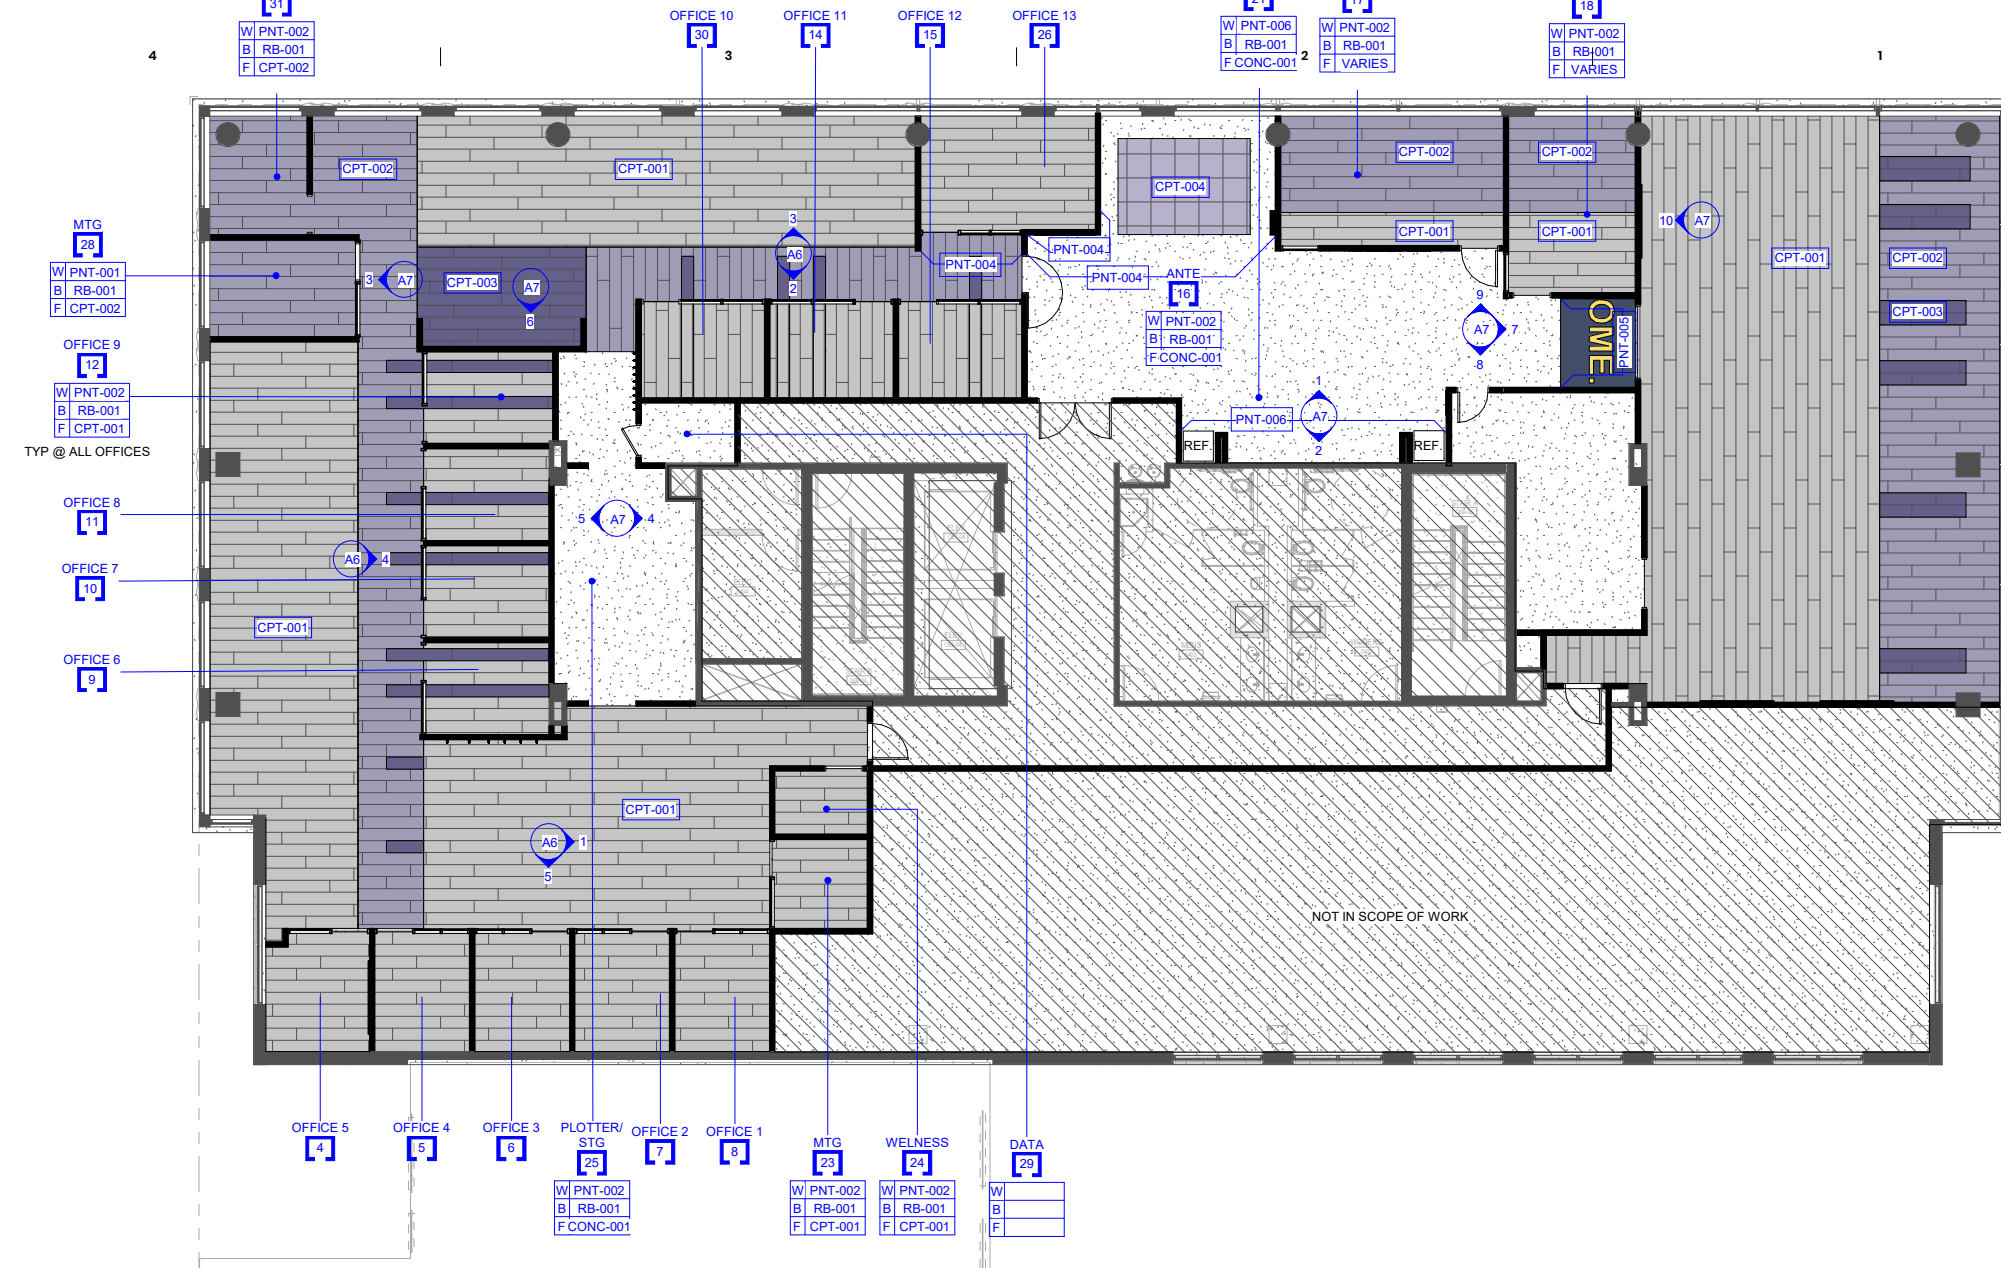

4C 3RD FLOOR FINISH PLAN

SCALE: 1/8"=1'-0"

FLOOR TRANSITION

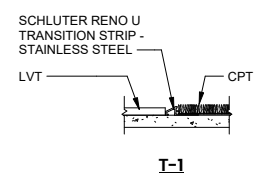

INTERIOR FINISH NOTES

- NOTE 1
- NOTE 2
- NOTE 3


FLOOR PLAN NOTES

- PLAN NOTES:**
- OFFICE & CONFERENCE FACADES
 OPTION A: STOREFRONT GLASS. DOORS TO BE GLASS SLIDER OR WOOD WITH FULL GLASS LITE.
 OPTION B: TO HAVE 4' X 4' FRAMELESS GLASS.
 - ALL ENCLOSED ROOMS TO HAVE ACP @ 8'-6" AFF
 - BREAK/ ANTE - EXPOSED TO DECK
 - OPEN OFFICE EXPOSED TO DECK WITH DROPPED ACP

USABLE SQ. FT.:
 PlanRVA SPACE - 7,297 SF
 VACANT SPACE - 2,353 SF

4A 3RD FLOOR FLOOR PLAN

SCALE: 1/8"=1'-0"

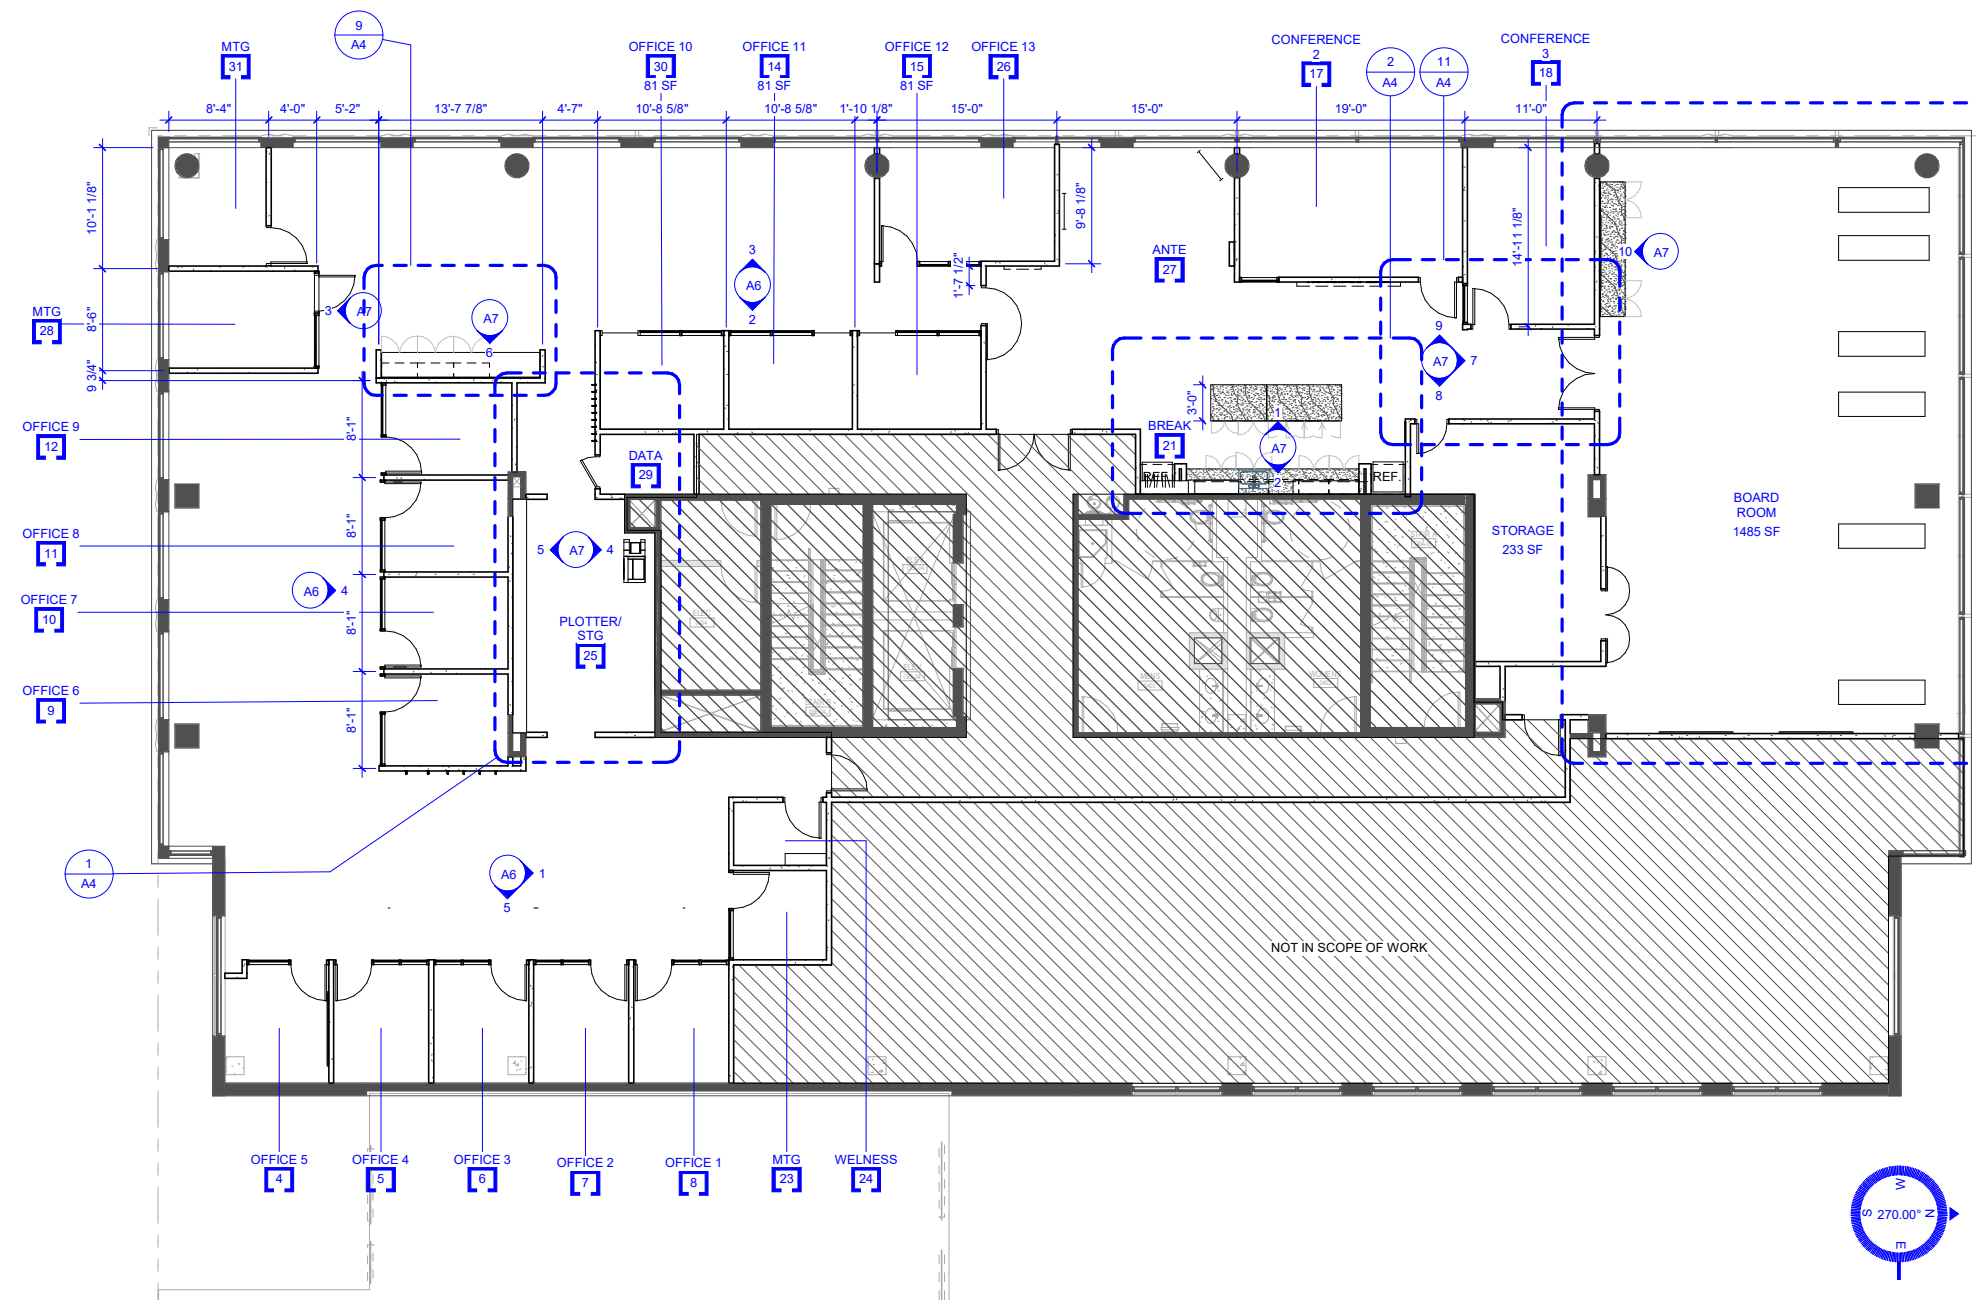

BASKERVILL, P.O. BOX 400, RICHMOND, VA 23218-0400

NOT FOR CONSTRUCTION

PROJECT NUMBER
2.210746.0

PlanRVA TI - THE CURRENT


424 Hull St, Richmond, VA 23224

ISSUE
4/13/2022 -
SCHEMATIC DESIGN


FLOOR PLAN
A1




4 ACT BOH Copy 1
SCALE:

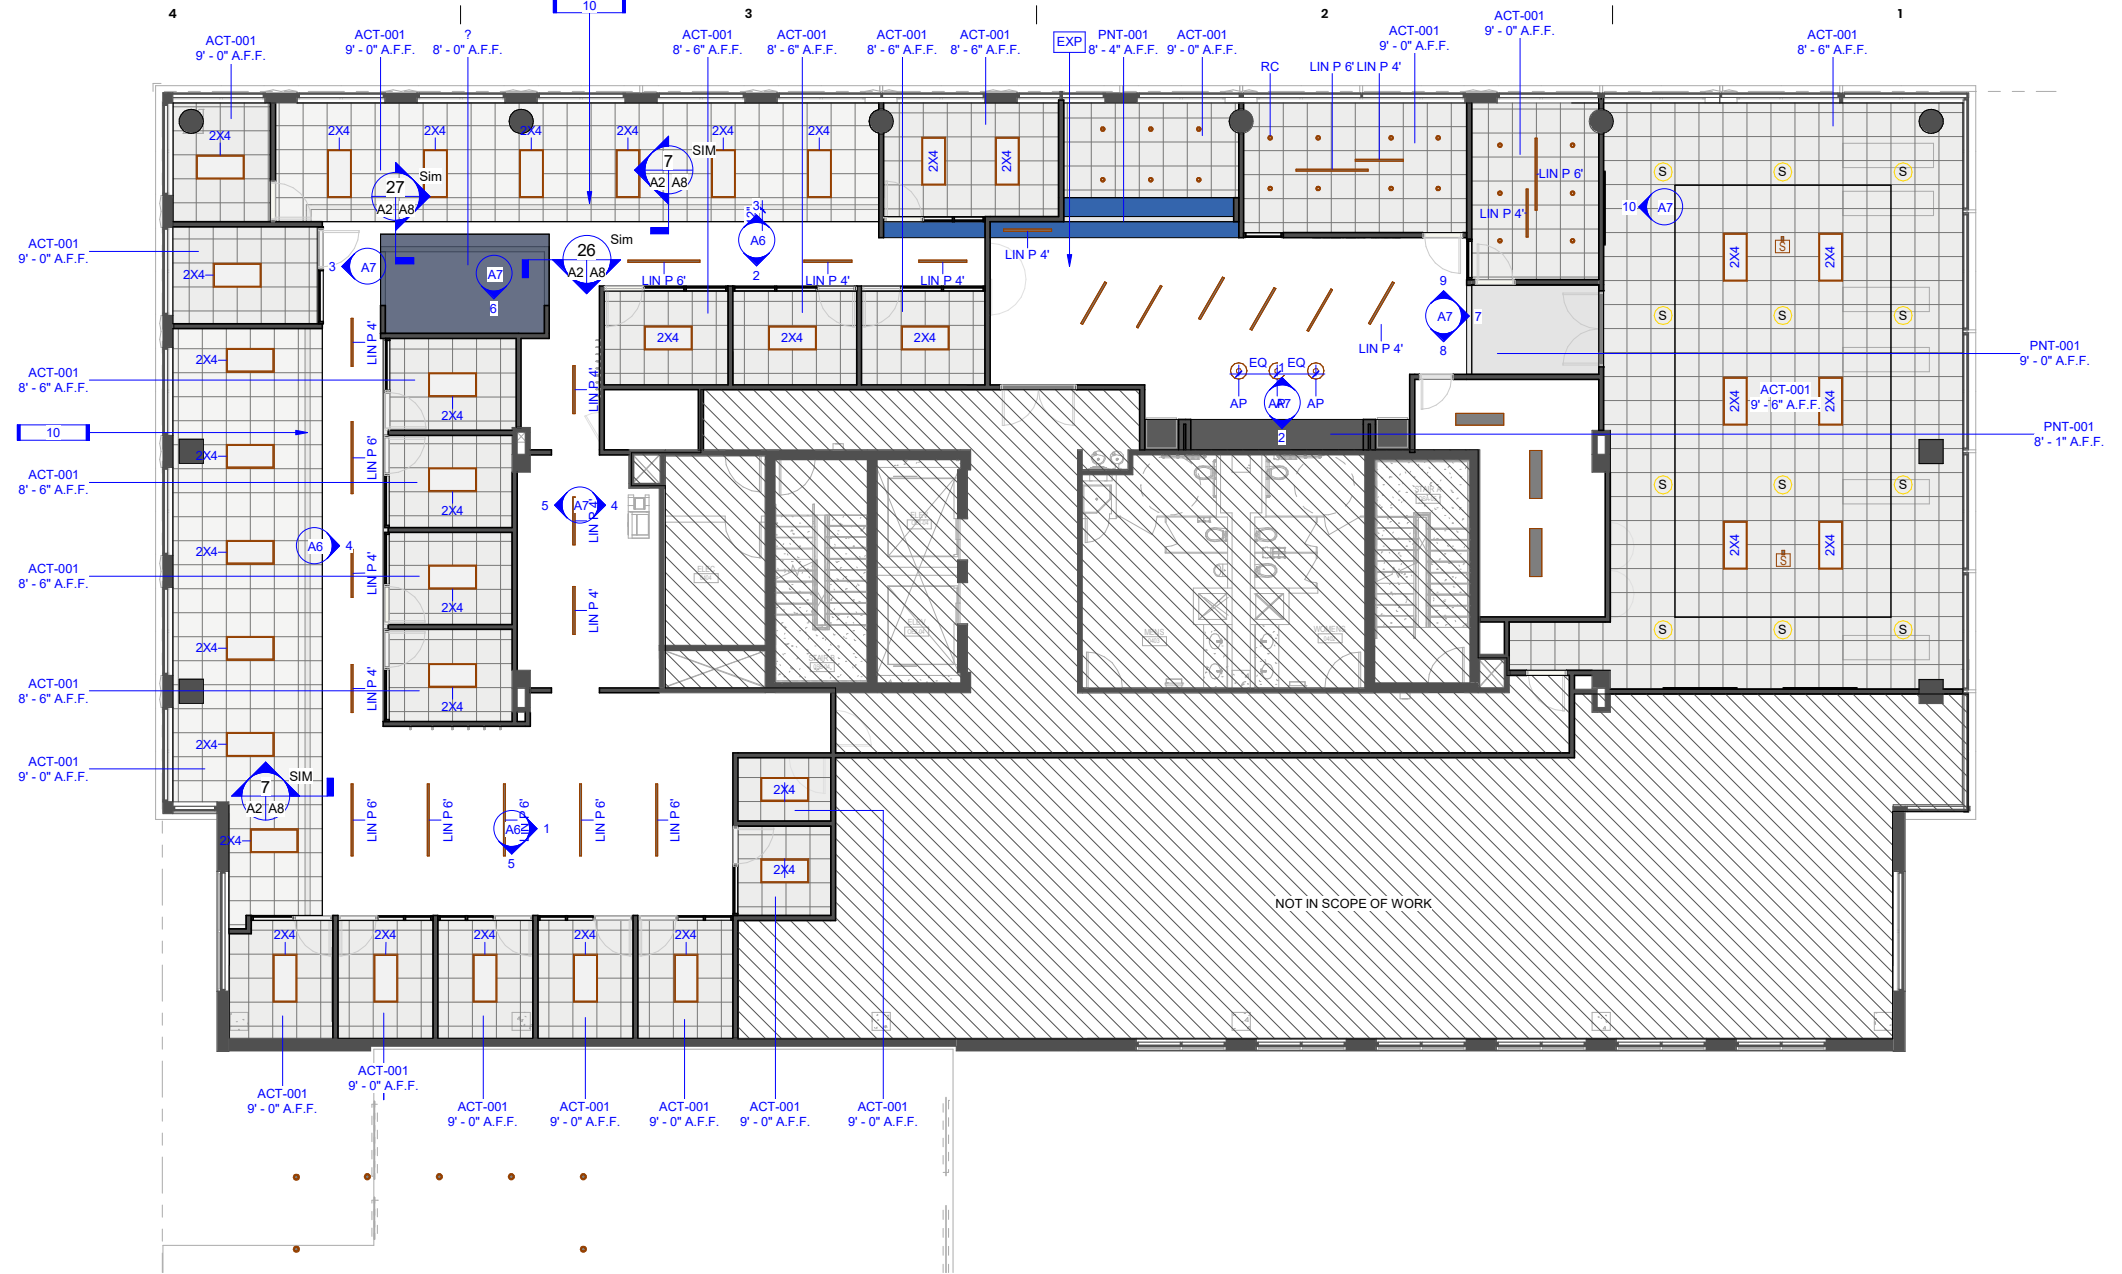

4C 3RD FLOOR - REFLECTED CEILING PLAN - AD ALT
SCALE: 1/8"=1'-0"

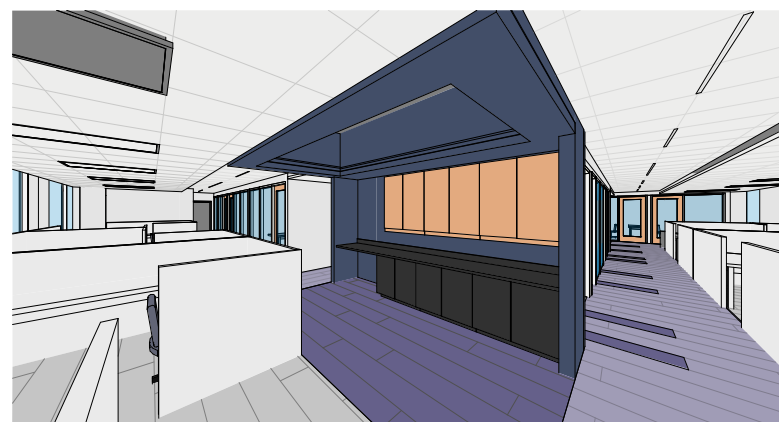


3 ACT BOH
SCALE:

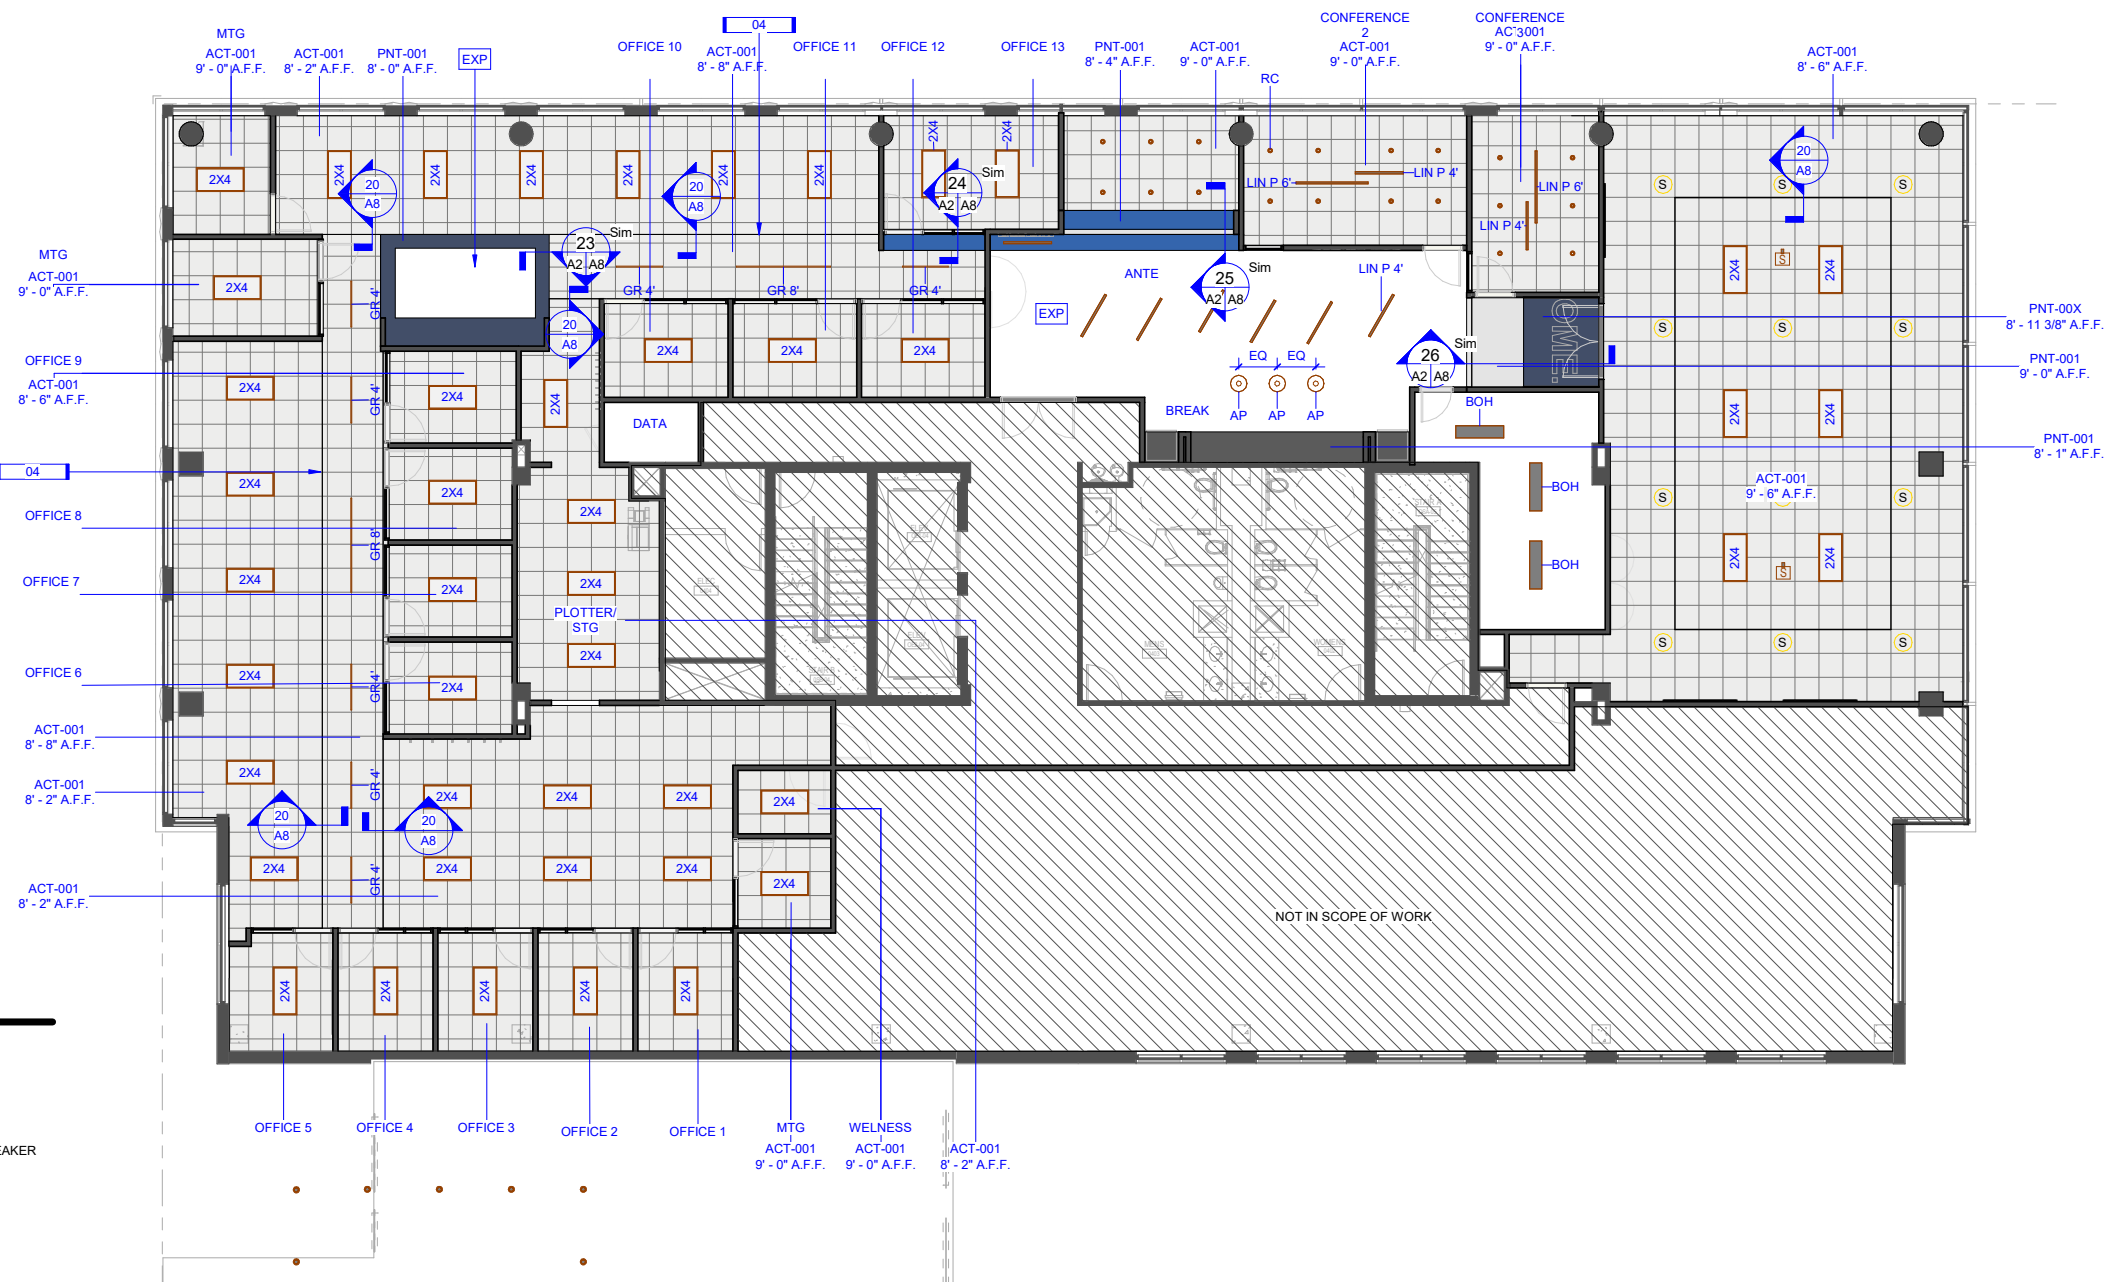


4A 3RD FLOOR - REFLECTED CEILING PLAN
SCALE: 1/8"=1'-0"


REFLECTED CEILING PLAN

- | | | | |
|--|---|--|--------------------------|
| | 2'x2' LIGHT FIXTURE | | SPRINKLER |
| | 2'x4' LIGHT FIXTURE | | SECURITY CAMERA |
| | STRIP FLUORESCENT LIGHT FIXTURE | | FLUSH MOUNTED PA SPEAKER |
| | RECESSED CAN LIGHT FIXTURE | | EXHAUST GRILLE |
| | PENDANT LIGHT FIXTURE | | RETURN GRILLE |
| | WALL MOUNTED LIGHT FIXTURE | | SUPPLY DIFFUSER |
| | EMERGENCY WALL MOUNTED LIGHT FIXTURE WITH BATTERY BACKUP - REFER TO ELEC. | | SUSPENDED CEILING SYSTEM |
| | EXIT SIGN | | |

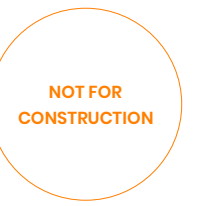

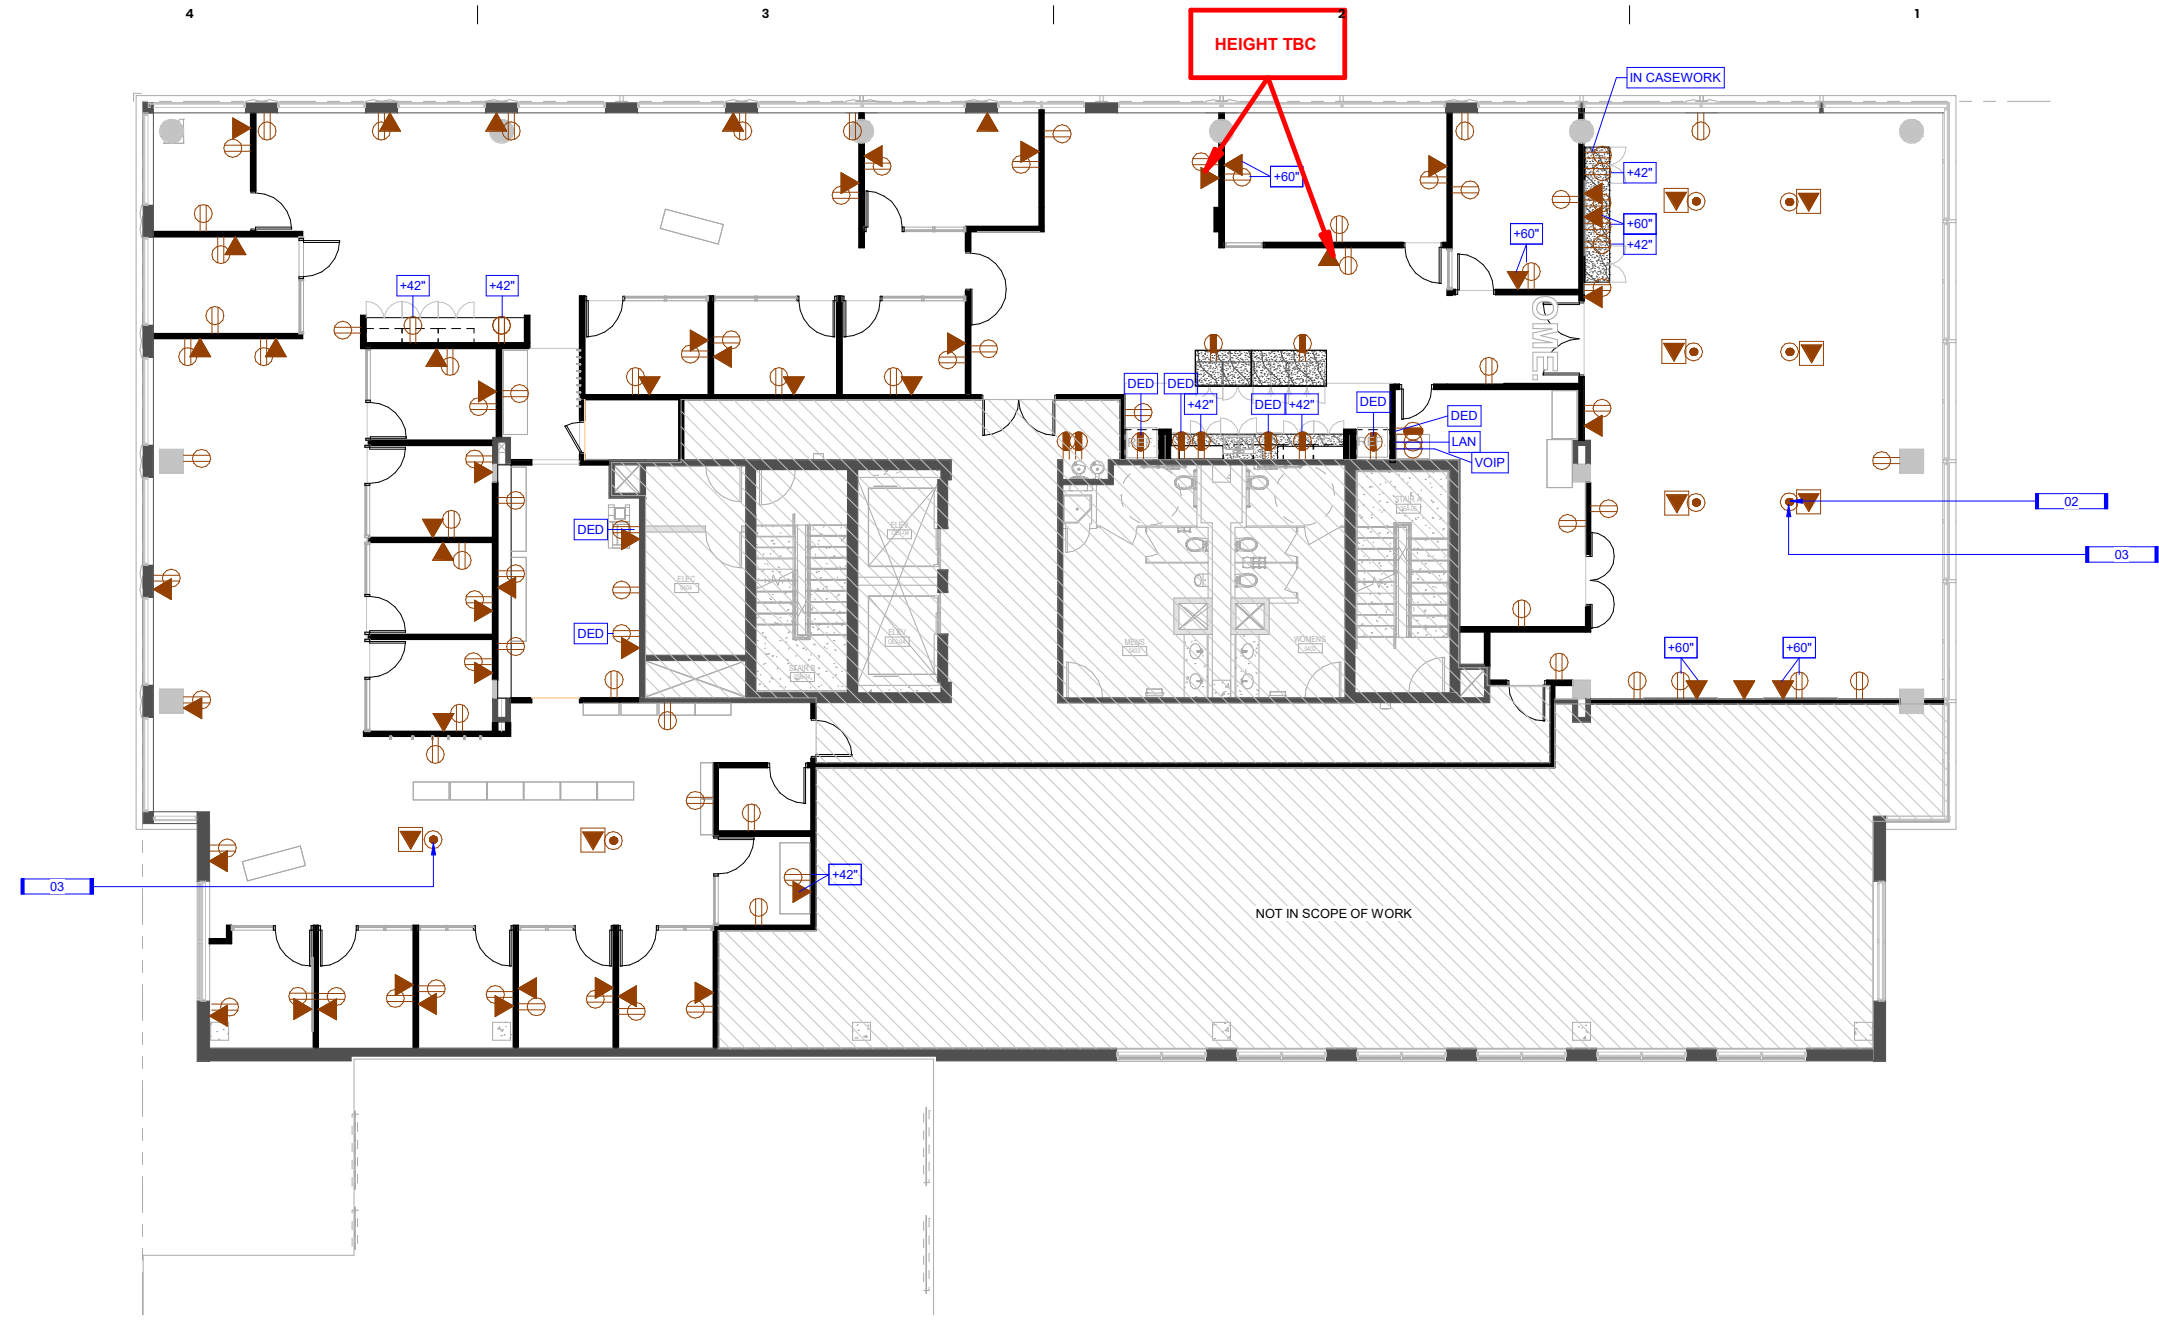

2 3RD FLOOR POWER PLAN
SCALE: 1/8" = 1'-0"

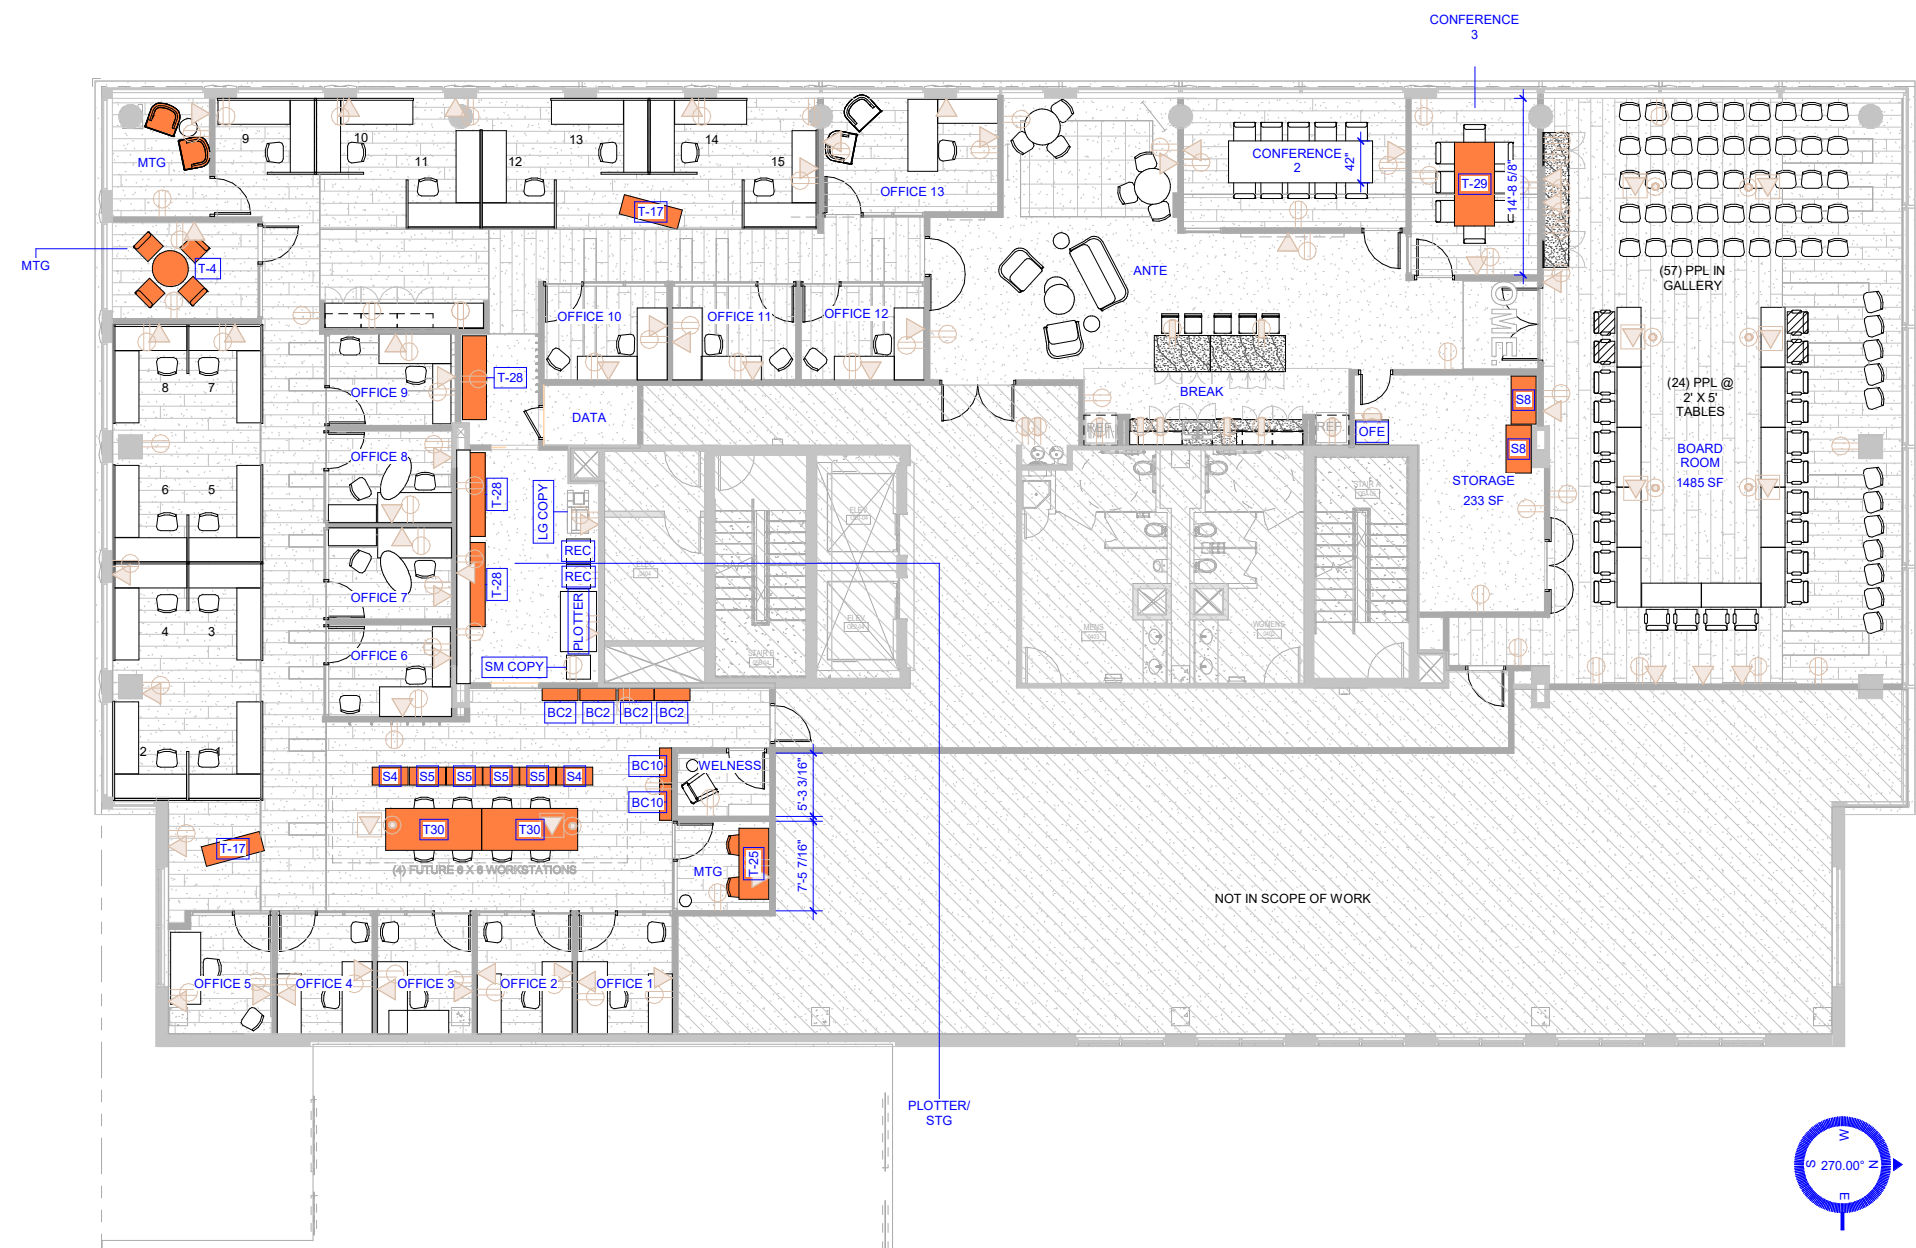

1 3RD FLOOR - FURNITURE PLAN (FOR REFERENCE ONLY)
SCALE: 1/8" = 1'-0"

BASKERVILL, P.O. BOX 400, RICHMOND, VA 23218-0400

NOT FOR CONSTRUCTION

COPYRIGHT 2021 BASKERVILL. USE OF THIS WORK IN WHOLE OR IN PART IS FORBIDDEN WITHOUT EXPRESSED WRITTEN CONSENT.

PROJECT NUMBER
2.210746.0

PlanRVA TI - THE CURRENT

424 Hull St, Richmond, VA 23224

ISSUE
4/13/2022 -
< SCHEMATIC DESIGN

FURNITURE + POWER PLAN
A3

NOT FOR CONSTRUCTION


PROJECT NUMBER
2.210746.0

PlanRVA TI - THE CURRENT


424 Hull St, Richmond, VA 23224

ISSUE
4/13/2022 -
SCHEMATIC DESIGN


ENLARGED PLANS
A4

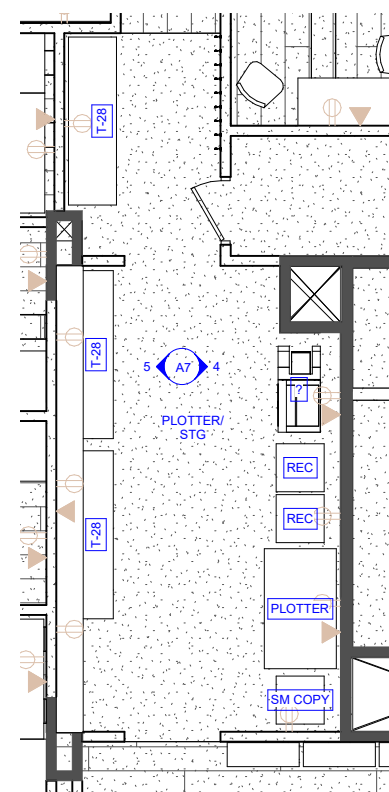


1 ENLARGED FLOOR PLAN - PLOTTER / STG ROOM
SCALE: 1/4" = 1'-0" DRAWING REF: A1

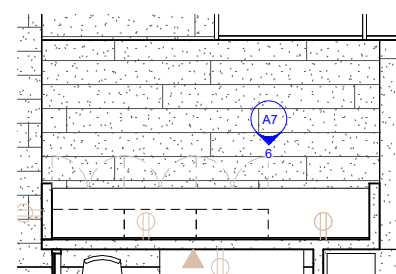


9 ENLARGED FLOOR PLAN - SUPPLIES
SCALE: 1/4" = 1'-0" DRAWING REF: A1

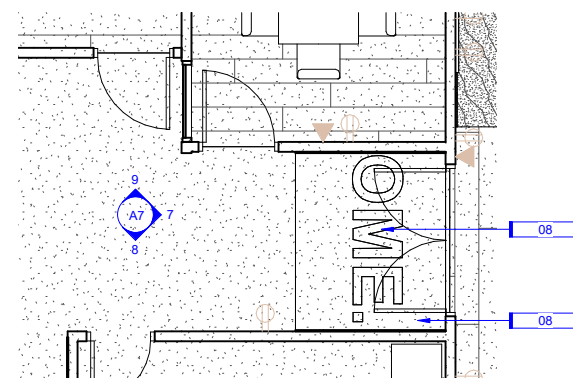

11 ENLARGED FLOOR PLAN - BOARD ROOM ENTRY
SCALE: 1/4" = 1'-0" DRAWING REF: A1

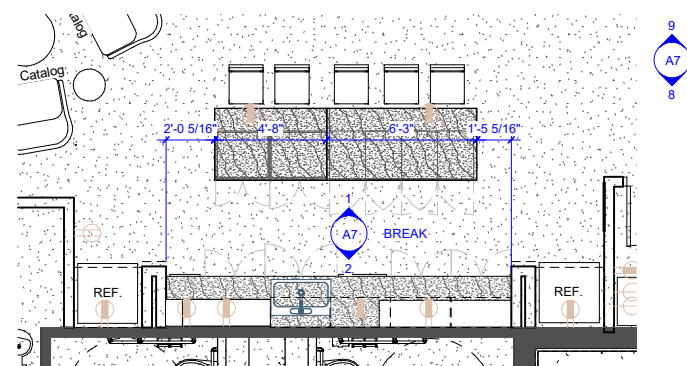

2 ENLARGED FLOOR PLAN - BREAK ROOM
SCALE: 1/4" = 1'-0" DRAWING REF: A1

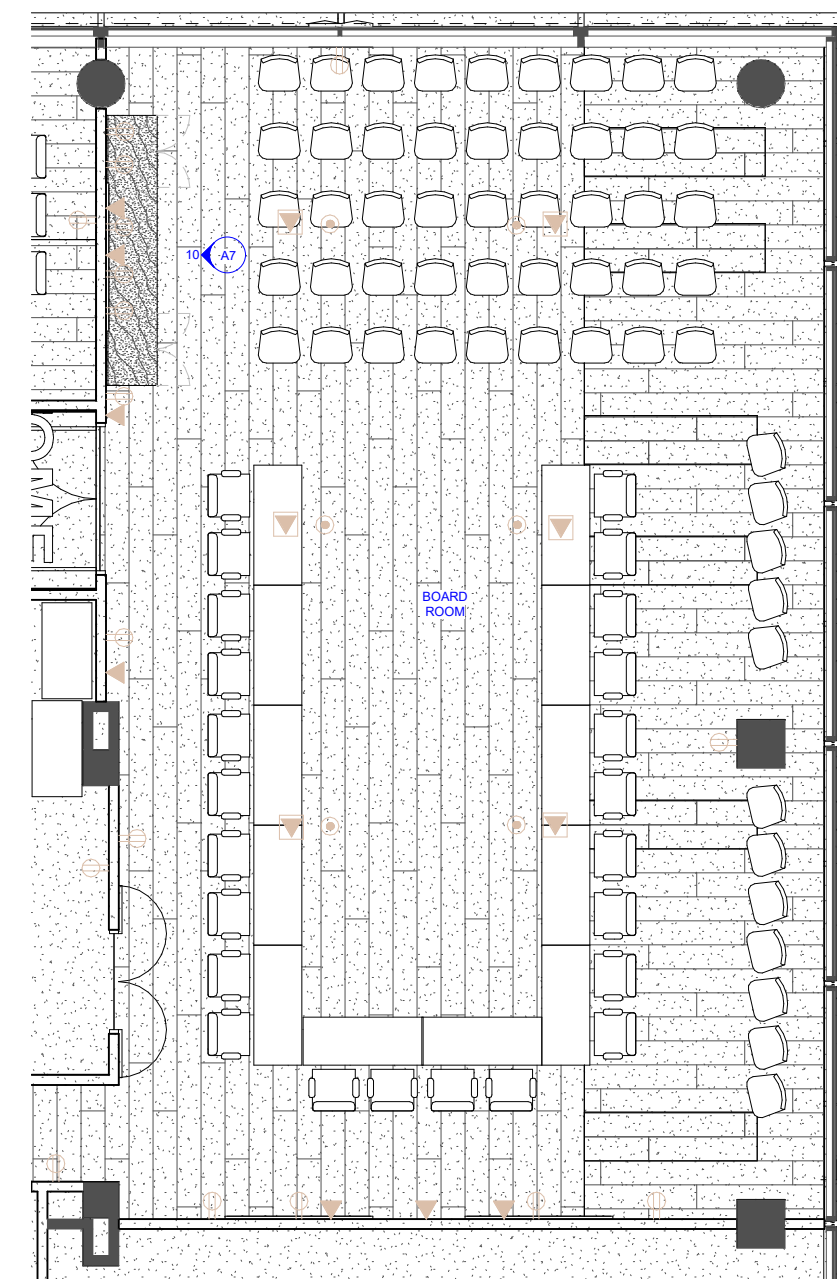

3 ENLARGED FLOOR PLAN - BOARD ROOM
SCALE: 1/4" = 1'-0" DRAWING REF: A1



5 3D View 6
SCALE:



6 3D View 7
SCALE:



9 3D View 10
SCALE:




2 3D View 4
SCALE:



1 3D View 1
SCALE:




4 3D View 5
SCALE:

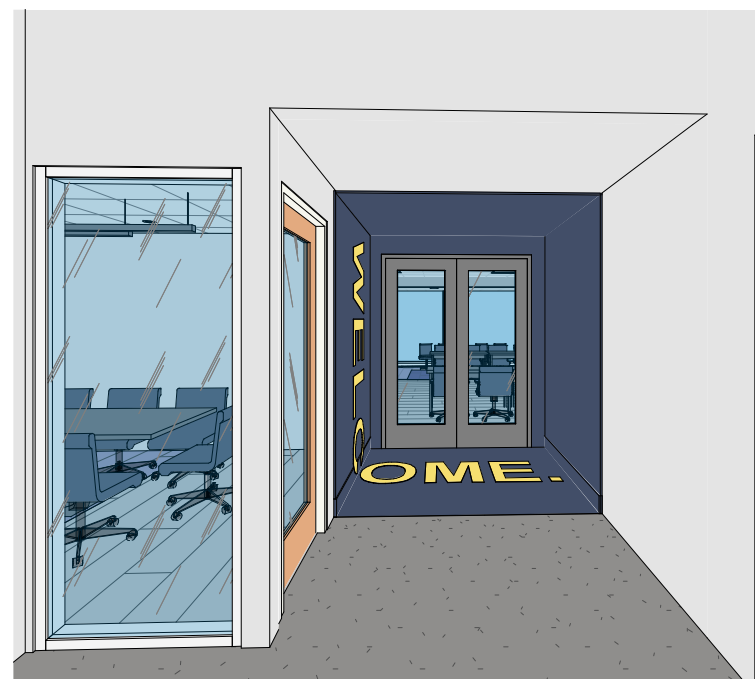

7 3D View 3
SCALE:



8 3D View 8
SCALE:

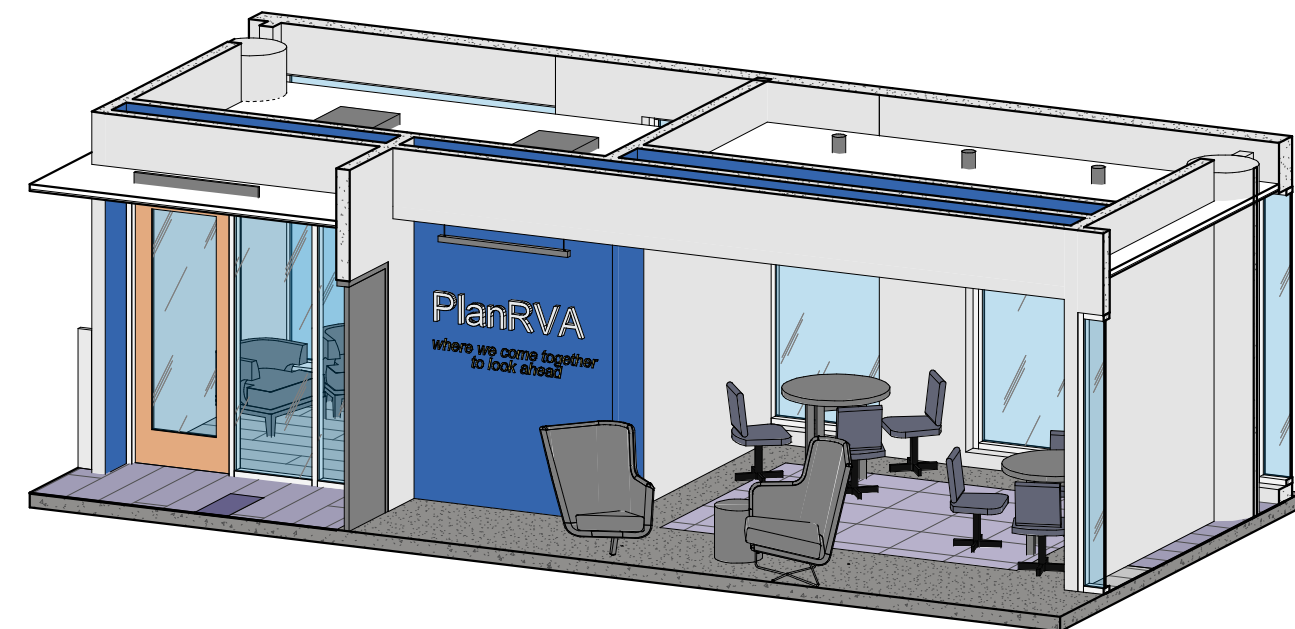

3 ENTRY
SCALE:

BASKERVILL, P.O. BOX 400, RICHMOND, VA 23210-0400

NOT FOR CONSTRUCTION

COPYRIGHT 2021 BASKERVILL. USE OF THIS WORK IN WHOLE OR IN PART IS FORBIDDEN WITHOUT EXPRESSED WRITTEN CONSENT.


PROJECT NUMBER
2.210746.0

PlanRVA TI - THE CURRENT

424 Hull St, Richmond, VA 23224

ISSUE
4/13/2022 -
SCHEMATIC DESIGN

3D VIEWS
A5

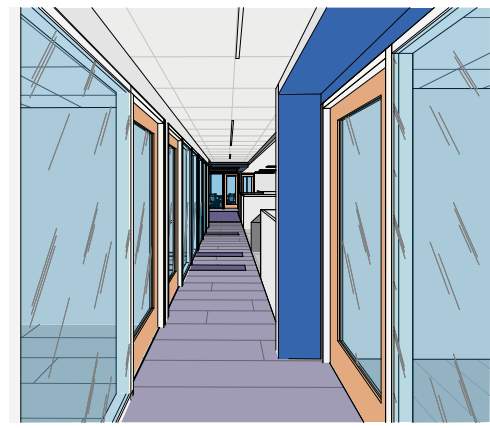


9 3D VIEW - BOH MAIN ENTRY
SCALE:



11 3D VIEW - FUTURE WORKSTATION AREA (INTERNS)
SCALE:




12 3D VIEW - OFFICES 1 - 5
SCALE:

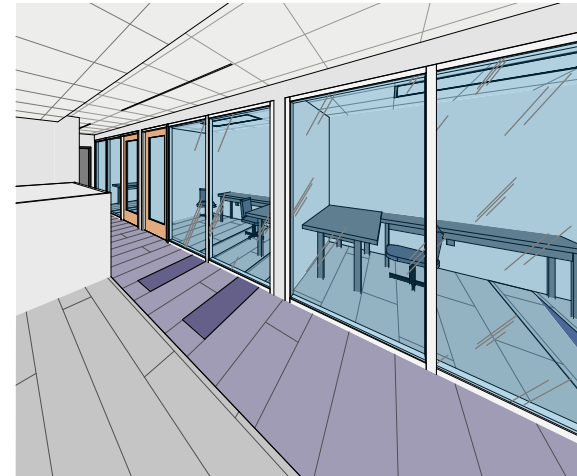


7 3D VIEW OFFICES 10 - 12
SCALE:




10 3D VIEW - OFFICES 6 - 9
SCALE:

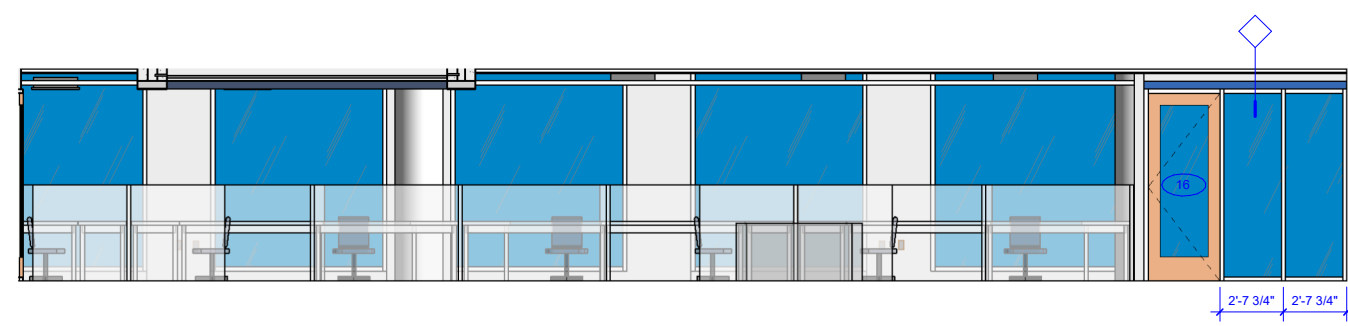


3 ELEV - OFFICE 13 + OPEN WORK AREA
SCALE: 1/4"=1'-0" DRAWING REF: A1

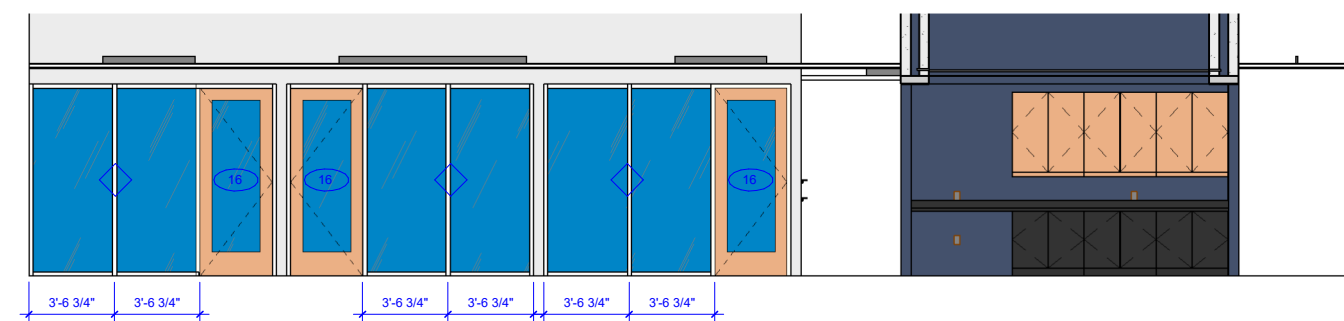


2 ELEV - OFFICES 10-12
SCALE: 1/4"=1'-0" DRAWING REF: A1

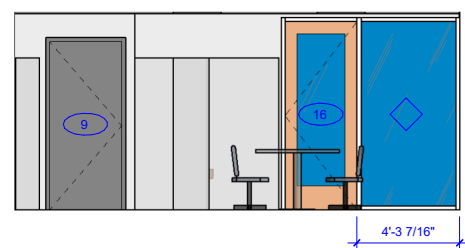

1 ELEV - MEETING + BACK OF HOUSE ENTRY
SCALE: 1/4"=1'-0" DRAWING REF: A1

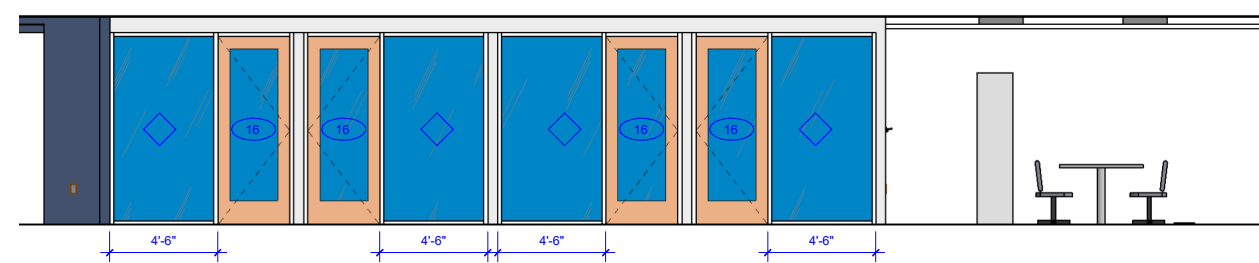

4 ELEV - OFFICES 6-9
SCALE: 1/4"=1'-0" DRAWING REF: A1

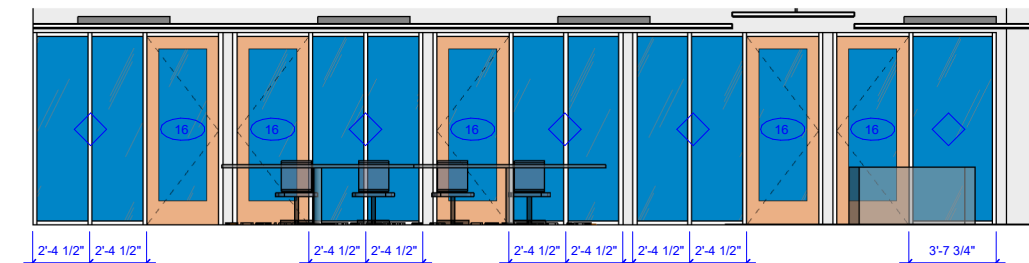

5 ELEV - OFFICES 1 - 5
SCALE: 1/4"=1'-0" DRAWING REF: A1

BASKERVILL, P.O. BOX 400, RICHMOND, VA 23218-0400

NOT FOR CONSTRUCTION

COPYRIGHT 2021 BASKERVILL. USE OF THIS WORK IN WHOLE OR IN PART IS FORBIDDEN WITHOUT EXPRESSED WRITTEN CONSENT.


PROJECT NUMBER
2.210746.0

PlanRVA TI - THE CURRENT

424 Hull St, Richmond, VA 23224


ISSUE
4/13/2022 - SCHEMATIC DESIGN

ELEVATIONS
A6

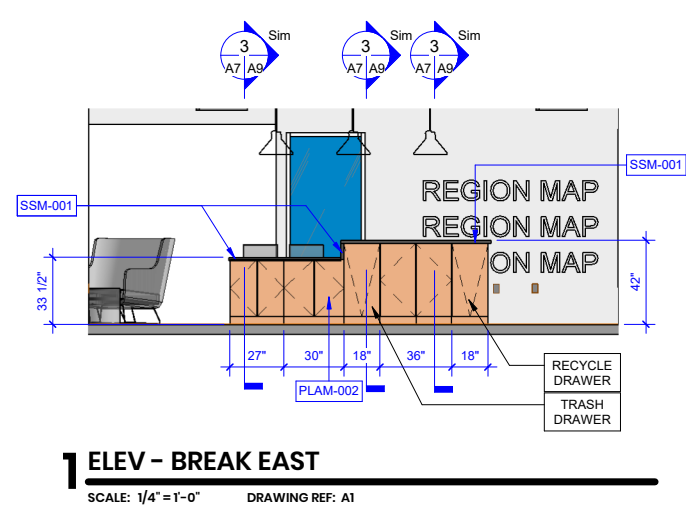


1 ELEV - BREAK EAST

SCALE: 1/4" = 1'-0" DRAWING REF: A1

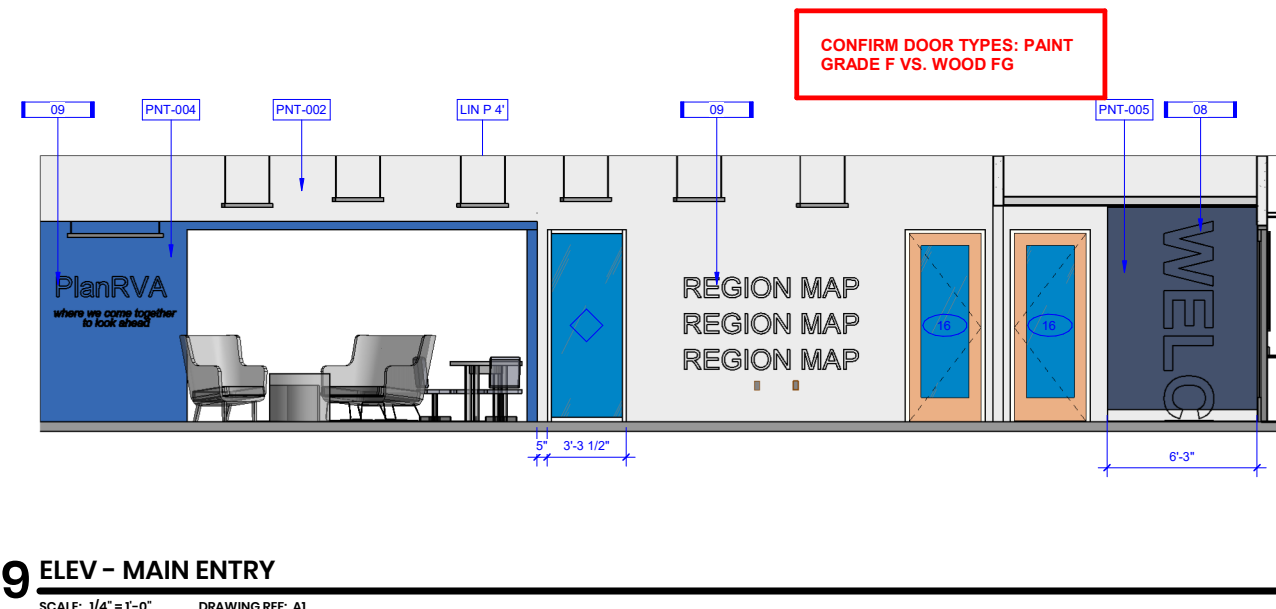

9 ELEV - MAIN ENTRY


SCALE: 1/4" = 1'-0" DRAWING REF: A1

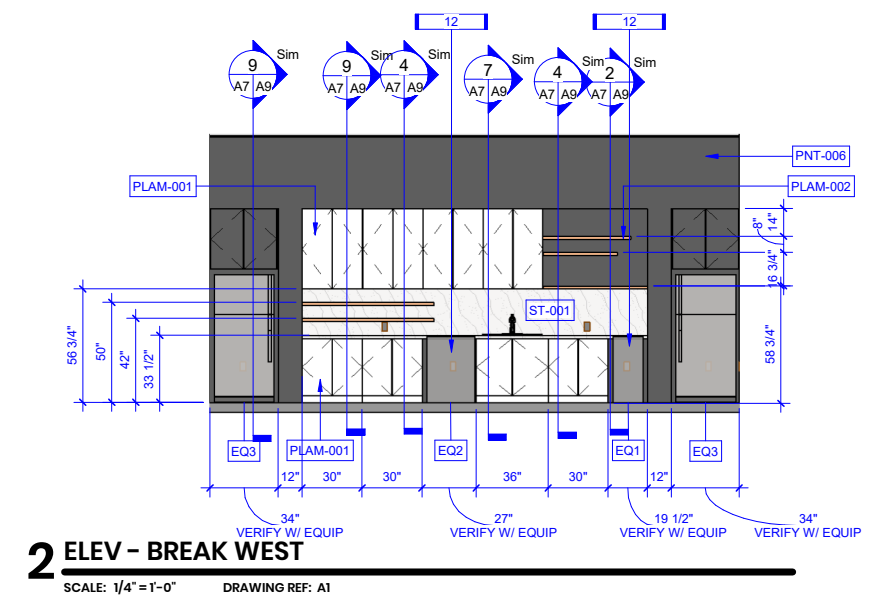

2 ELEV - BREAK WEST


SCALE: 1/4" = 1'-0" DRAWING REF: A1

BASKERVILL, P.O. BOX 400, RICHMOND, VA 23218-0400

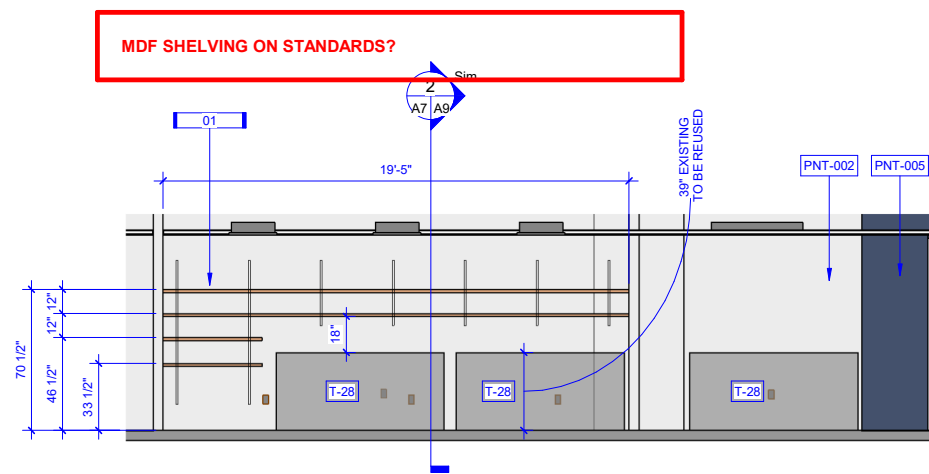


5 ELEV - PLOTTER / STORAGE SOUTH

SCALE: 1/4" = 1'-0" DRAWING REF: A1

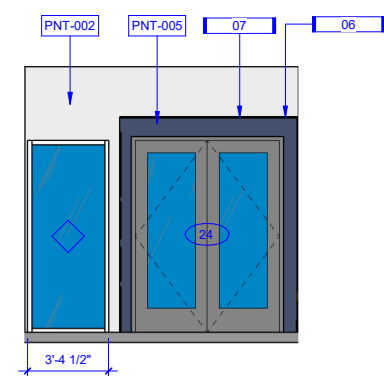


7 Elevation 1 - a

SCALE: 1/4" = 1'-0" DRAWING REF: A1

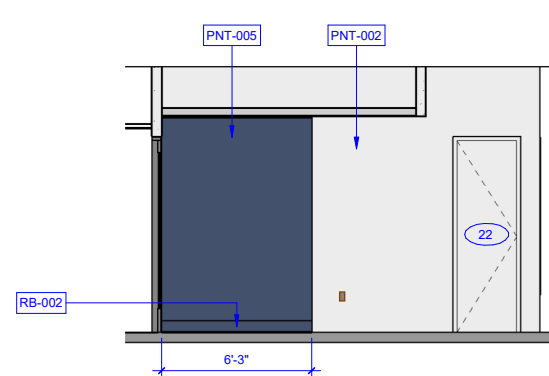

8 Elevation 1 - b

SCALE: 1/4" = 1'-0" DRAWING REF: A1

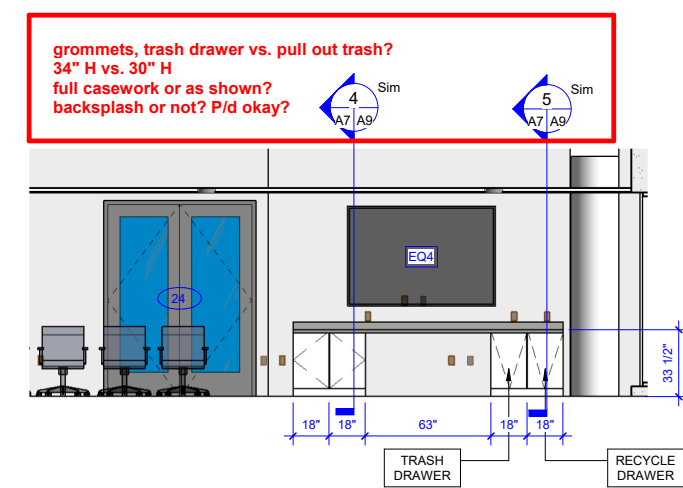

10 Elevation 2 - a

SCALE: 1/4" = 1'-0" DRAWING REF: A1


NOT FOR CONSTRUCTION

COPYRIGHT 2021 BASKERVILL. USE OF THIS WORK IN WHOLE OR IN PART IS FORBIDDEN WITHOUT EXPRESSED WRITTEN CONSENT.

PROJECT NUMBER
2.210746.0

PlanRVA TI - THE CURRENT

424 Hull St, Richmond, VA 23224

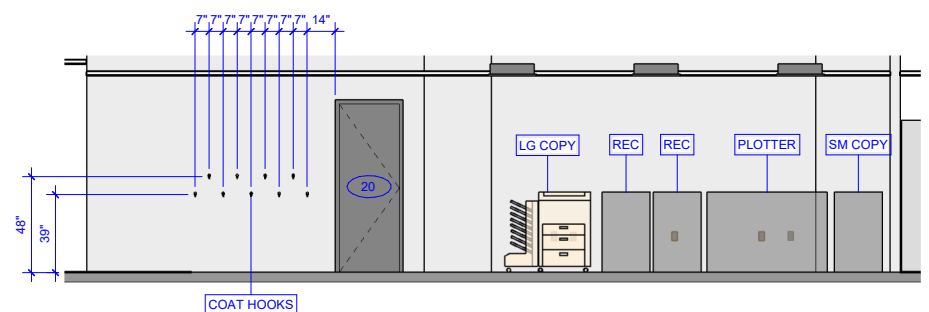


4 ELEV - PLOTTER / STORAGE NORTH

SCALE: 1/4" = 1'-0" DRAWING REF: A1



3 ELEV - MEETING + OPEN WORK AREA

SCALE: 1/4" = 1'-0" DRAWING REF: A1

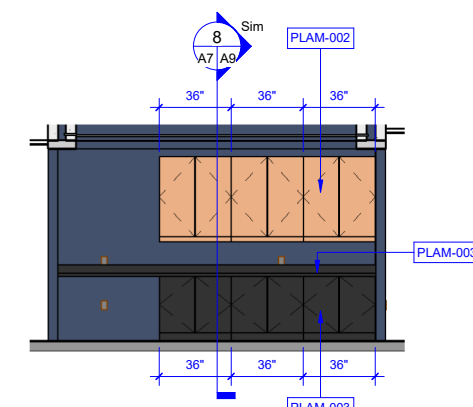

6 ELEV - SUPPLIES WEST

SCALE: 1/4" = 1'-0" DRAWING REF: A1

ISSUE
4/13/2022 -
SCHEMATIC DESIGN

ELEVATIONS
A7

AD ALTERNATE NOTES

GLASS WALLS
 1. BASE BID: PRIMARY DESIGN BASED OFF OF DEMOUNTABLE SYSTEM
 2. DEDUCTIVE ALTERNATE: STOREFRONT SYSTEM
 3. DEDUCTIVE ALTERNATE: HOLLOW METAL SYSTEM

LIGHTING AT HELP DESK
 1. BASE BID: PERIMETER LIGHTING SURROUNDING SOFFITS
 2. AD ALTERNATE: STRETCHED LIGHTING; BOD - BARRISOL LIGHT

DOORS
 1. BASE BID: SLIDING GLASS DOORS AT OFFICES + HUDDLE ROOMS
 2. DEDUCTIVE ALTERNATE: SWINGING SOLID WOOD DOOR

CARPET
 1. BASE BID: MATERIALS WITHIN DRAWING SET
 2. DEDUCTIVE ALTERNATE: CARPET AT INSTALLED PRICE OF \$30 PER SQUARE YARD

BASKERVILL, P.O. BOX 400, RICHMOND, VA 23218-0400



COPYRIGHT 2021 BASKERVILL. USE OF THIS WORK IN WHOLE OR IN PART IS FORBIDDEN WITHOUT EXPRESSED WRITTEN CONSENT.


PROJECT NUMBER
 2.210746.0

PlanRVA TI - THE CURRENT

424 Hull St, Richmond, VA 23224


26 CEILING DETAIL - GPDW SOFFIT Copy 1

SCALE: 1 1/2" = 1'-0" DRAWING REF: A2

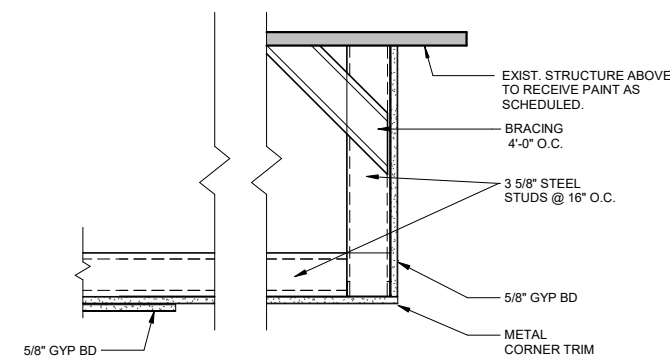


23 CEILING DETAIL - GPDW HEADER

SCALE: 1 1/2" = 1'-0" DRAWING REF: A2

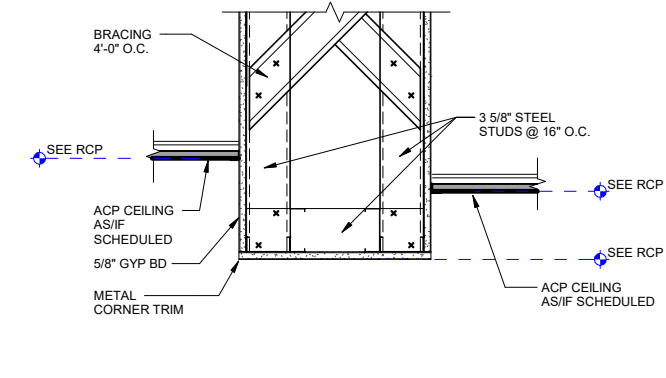


27 CEILING SOFFIT - GENERAL SOFFIT

SCALE: 1 1/2" = 1'-0" DRAWING REF: A2

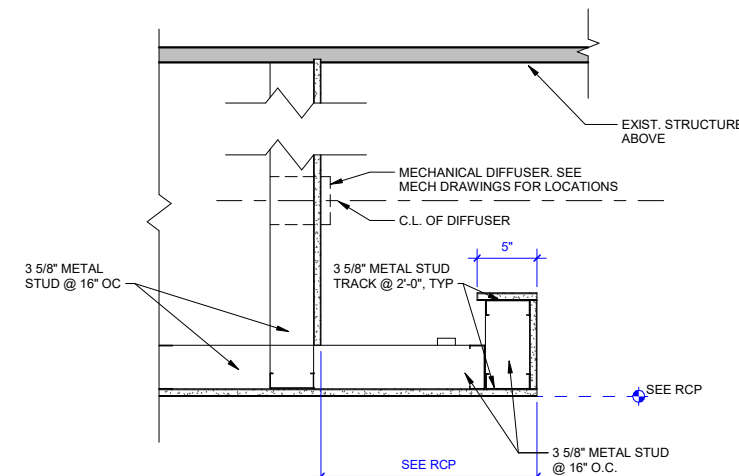


17 REVEAL

SCALE: 6" = 1'-0"

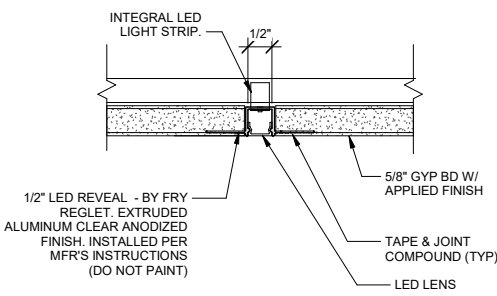


24 CEILING DETAIL - GPDW SOFFIT

SCALE: 1 1/2" = 1'-0" DRAWING REF: A2

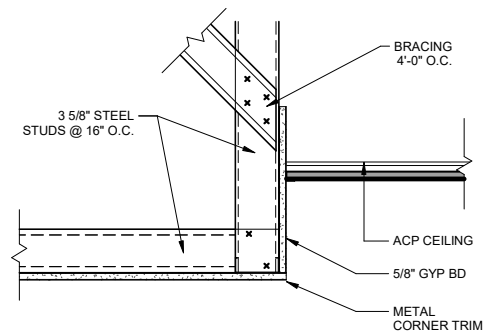


25 CEILING DETAIL - GPDW HEADER Copy 1

SCALE: 1 1/2" = 1'-0" DRAWING REF: A2

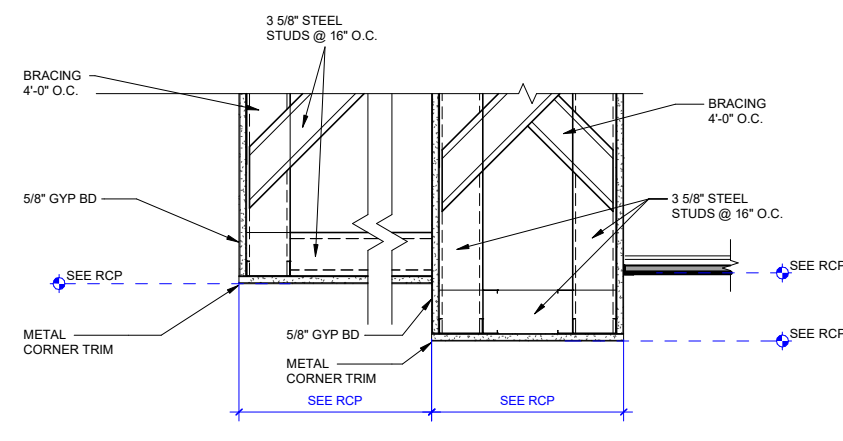


7 DETAIL - CEILING AT OPEN PLENUM

SCALE: 1 1/2" = 1'-0" DRAWING REF: A2

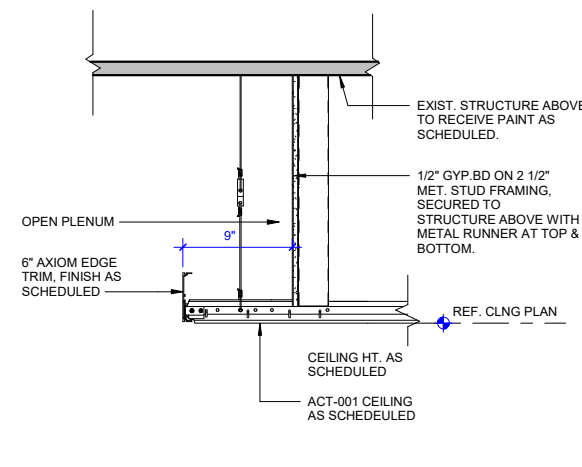


14 DETAIL - OFFICE GLASS PARTITION

SCALE: 1 1/2" = 1'-0"

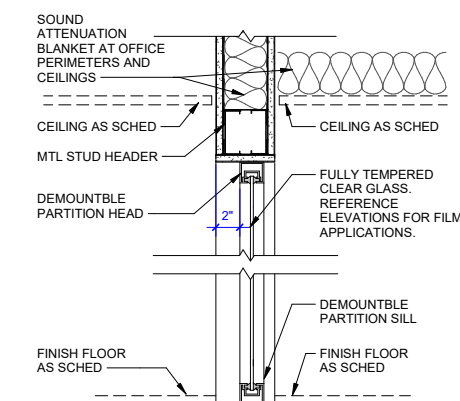


20 DETAIL - ACP TO ACP TRANSITION

SCALE: 1 1/2" = 1'-0" DRAWING REF: A2

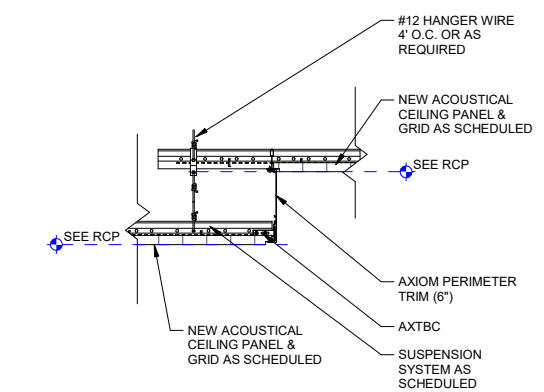


ISSUE
4/13/2022 -
 SCHEMATIC DESIGN


CEILING DETAILS
A8

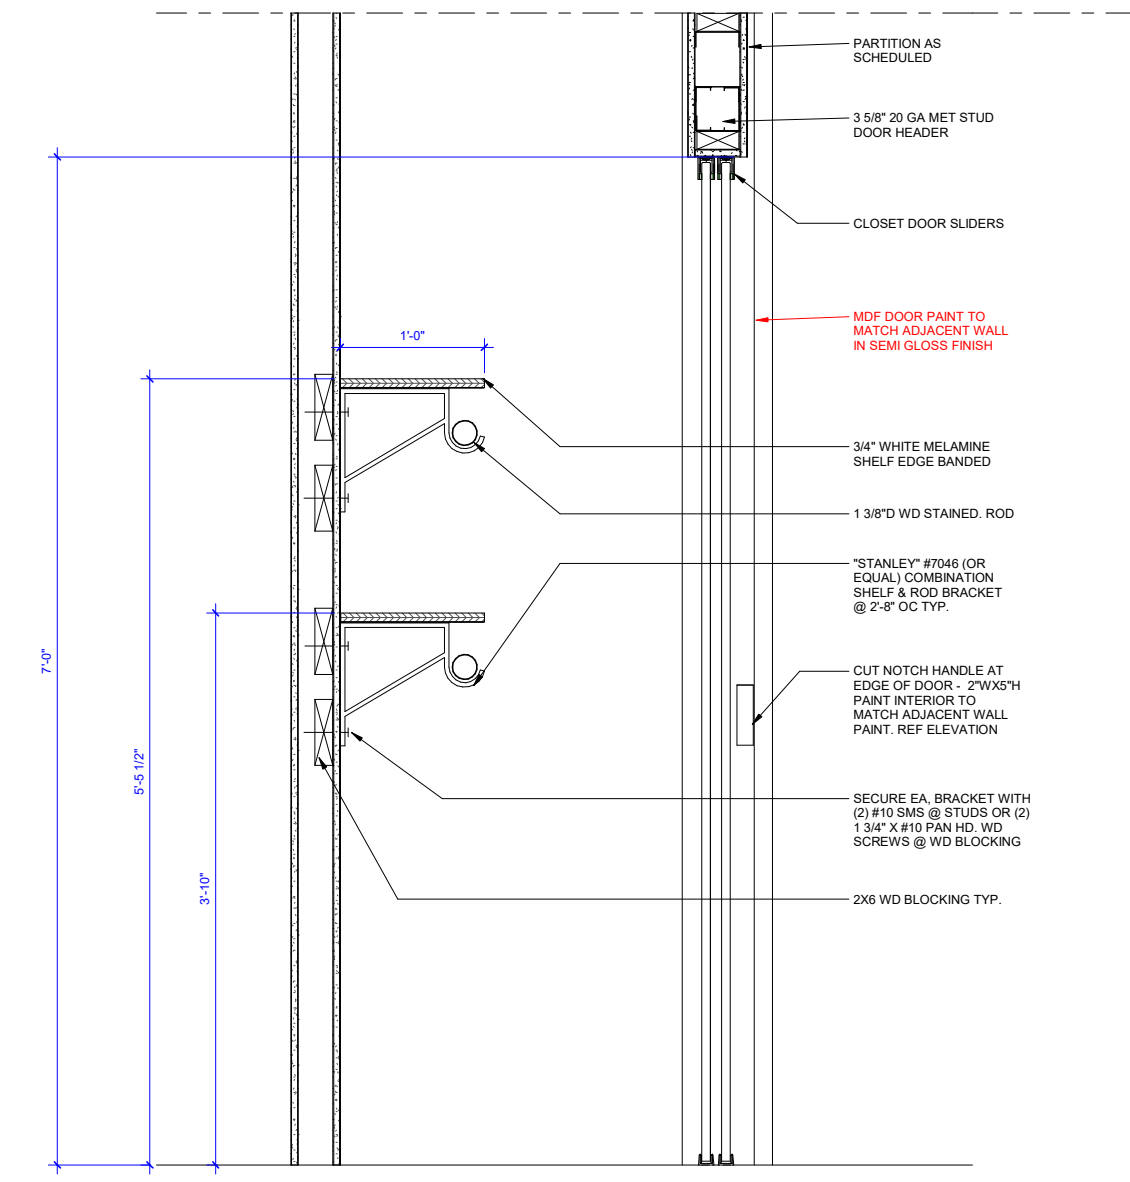


1 DETAIL - COAT CLOSET
SCALE: 1/2"=1'-0"
DRAWING REF: A7

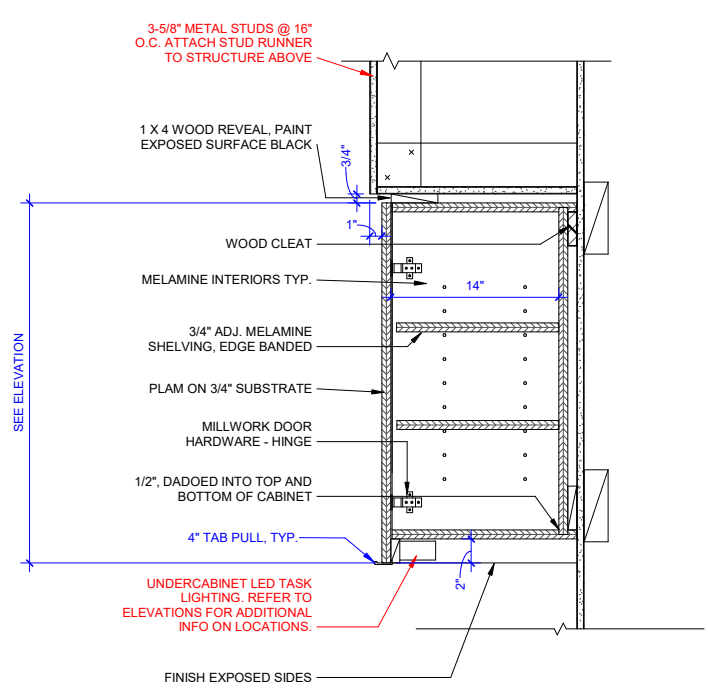


9 UPPER CABINETS W/ SOFFIT
SCALE: 1/2"=1'-0"
DRAWING REF: A7

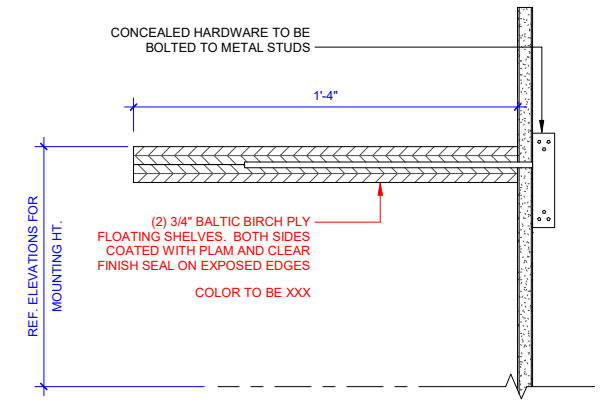


2 DETAIL - FLOATING SHELF
SCALE: 3"=1'-0"
DRAWING REF: A7

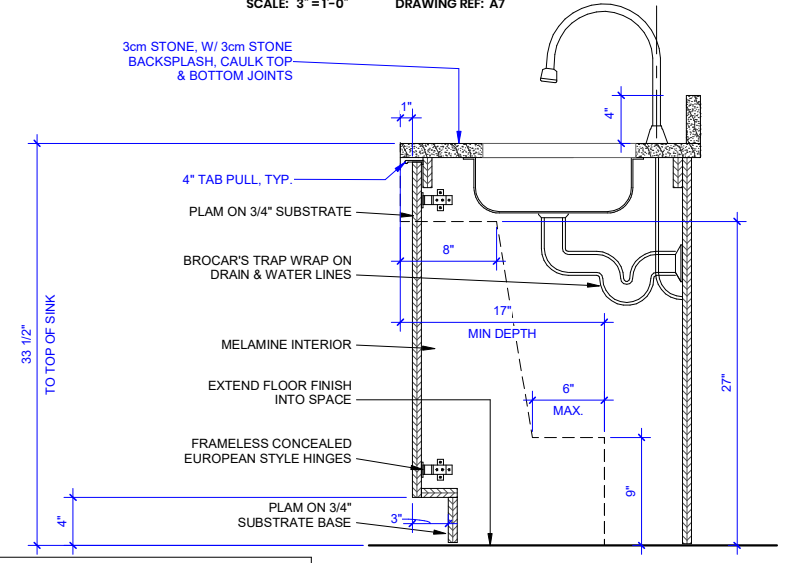


7 ADA BASE SINK CABINET
SCALE: 1/2"=1'-0"
DRAWING REF: A7

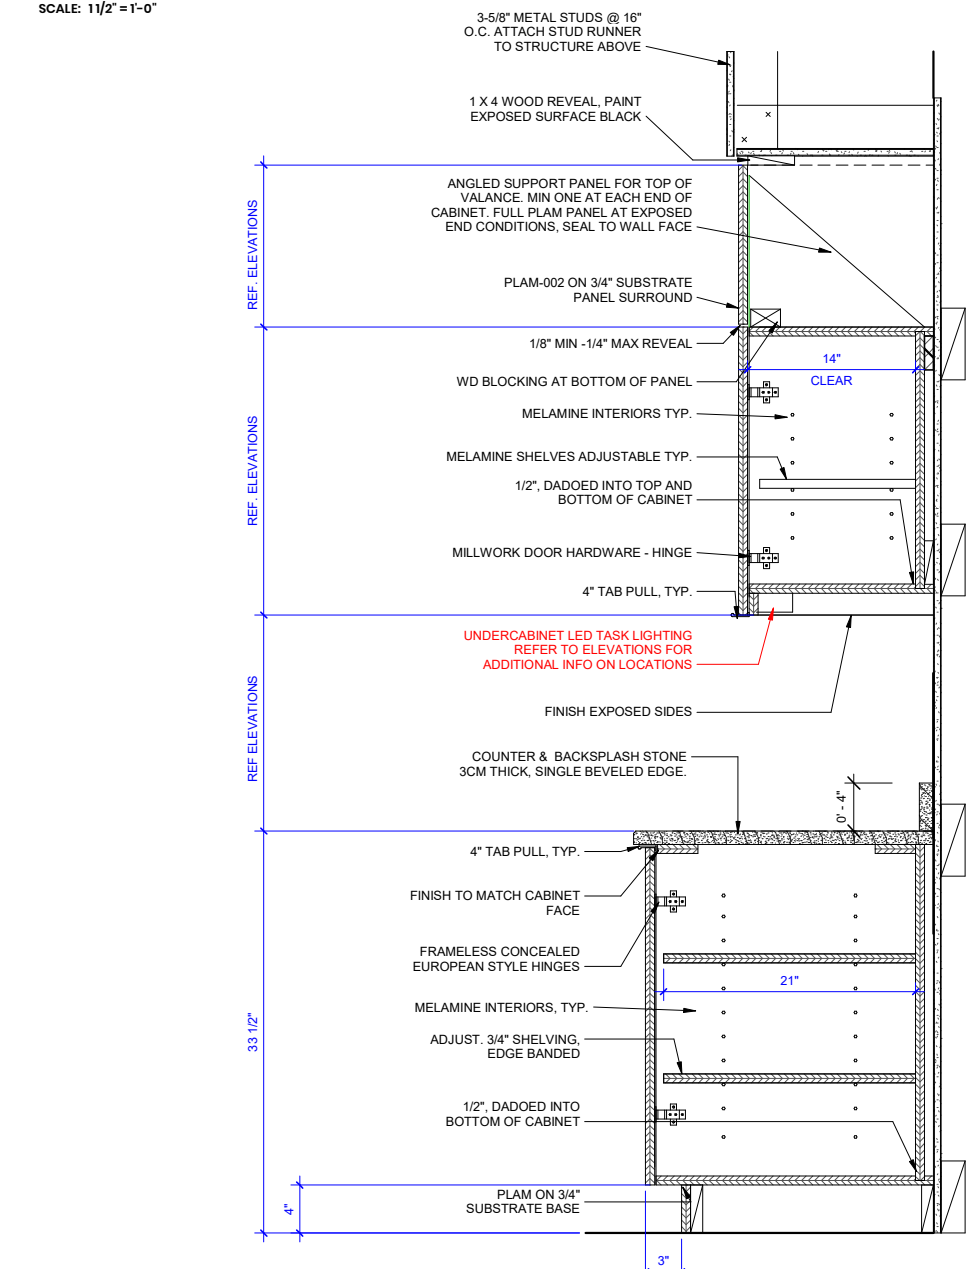


8 BASE & UPPER CABINET - BREAK ROOM
SCALE: 1/2"=1'-0"
DRAWING REF: A7

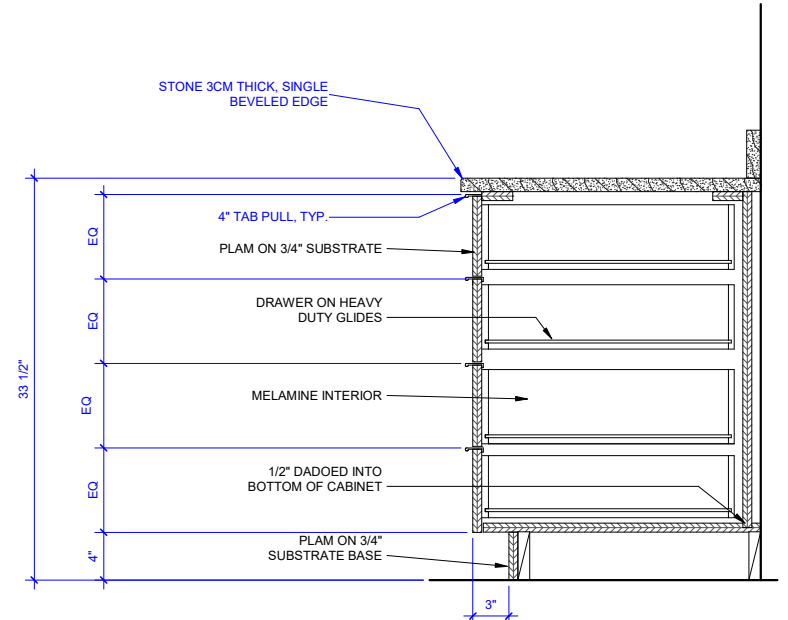


6 ADA BASE DRAWER CABINET
SCALE: 1/2"=1'-0"
DRAWING REF: A7

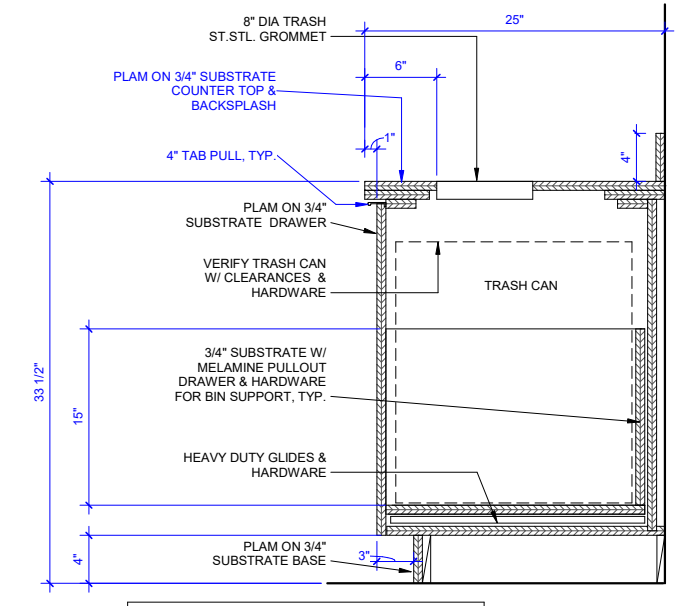

5 ADA BASE CABINET W/ TRASH DRAWER
SCALE: 1/2"=1'-0"
DRAWING REF: A7

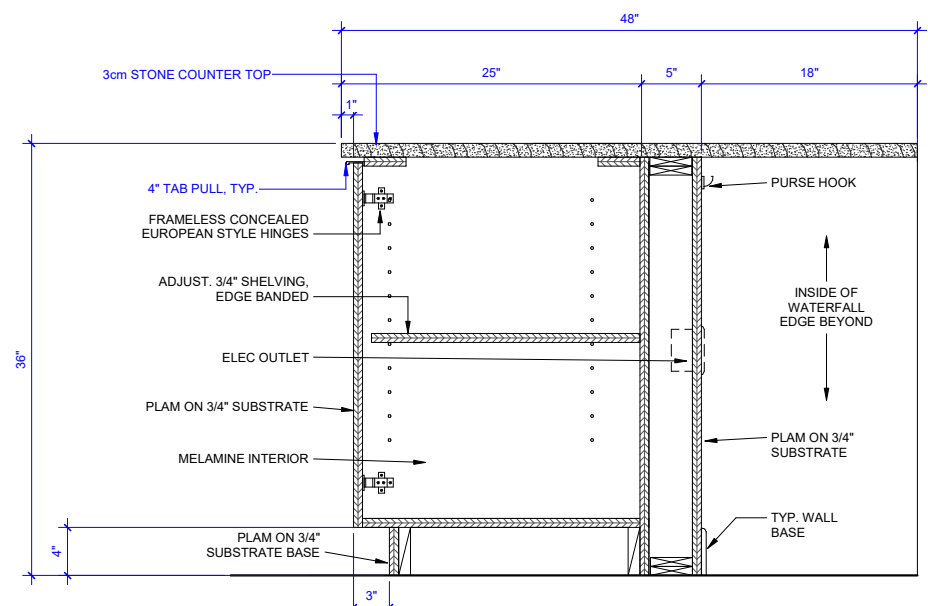


3 ISLAND - BASE CABINET
SCALE: 1/2"=1'-0"
DRAWING REF: A7

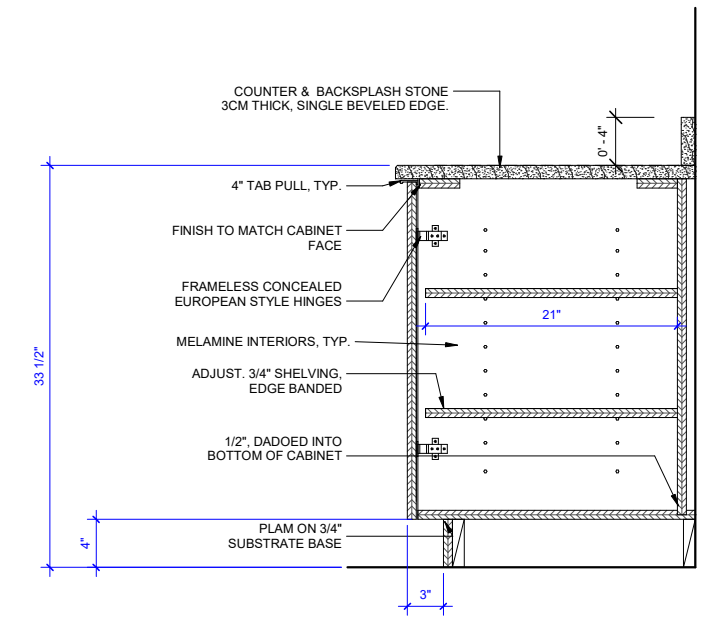

4 ADA BASE CABINET
SCALE: 1/2"=1'-0"
DRAWING REF: A7

BASKERVILL, P.O. BOX 400, RICHMOND, VA 23218-0400

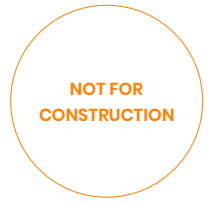

PROJECT NUMBER
2.210746.0

PlanRVA TI - THE CURRENT

424 Hull St, Richmond, VA 23224

ISSUE
4/13/2022 - SCHEMATIC DESIGN

CASEWORK DETAILS
A9